

RECEIVED
S.P.C.D. AND
PLANNING DEPT.




2011 NOV 30 PM 12:17

Vinny's Ristorante

76 Broadway, Somerville

Awnings & Signage Renovation

October 14, 2011 Submission to Planning Board

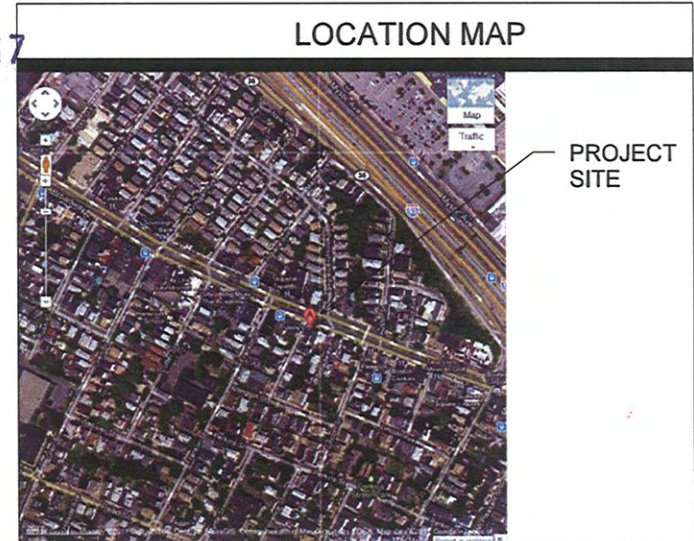

existing

Drawing List

Sheet Number	Sheet Name
A0.0	Cover
A0.1	Project Directory & Schedule
A0.2	Demolition RCP
A1	First Floor
A2	First Floor Reflected Ceiling Plan
A2.1	Enlarged Ceiling Plan
A3	Roof Plan
A3.1	Roof Plan Call Out
A4	North Elevation
A4.1	Entry Elevation
A5	West Elevation
A6	West Elevation--Call Out
A7	Details
A7.1	Details

DEREK RUBINOFF ARCHITECT

11 Sherwood Street #2, Roslindale, MA 02131-3729 617-504-2599 drubinoff@derek Rubinoff.com

Cover

Vinny's Ristorante
76 Broadway
Somerville, MA 02145

JOB #: 1122
SCALE: 1/4" = 1'-0"
DATE: 10/14/2011
DWN BY: Author
CROSS REF:

A0.0

RECEIVED
S.P.C.D. AND
PLANNING DEPT.

2011 NOV 30 PM 12:17

PROJECT DIRECTORY

ARCHITECT:

Derek Rubinoﬀ, Architect
11 Sherwood St. #2
Roslindale, MA 02131-3729
CONTACT: Derek Rubinoﬀ, AIA, LEED AP
MOBILE: (617) 504-2599
EMAIL: drubinoﬀ@derekubinoﬀ.com

FACILITATOR:

Mayor's Office of Strategic Planning
& Community Development
City of Somerville
93 Highland Avenue
Somerville, MA 02143
CONTACT: David Guzman
PHONE: (617) 625-6600 x 2546
EMAIL: DGuzman@somervillema.gov

TENANT:

VINNY'S RISTORANTE
76 Broadway
Somerville, MA 02145
CONTACT: Vinny Migliore
PHONE: (617) 285-2567
EMAIL: Luna331CA@yahoo.com

CODE SUMMARY

APPLICABLE CODES

BOSTON, MASSACHUSETTS

1. BUILDING 780 CMR: MASSACHUSETTS STATE
BUILDING CODE, 8TH EDITION

DESCRIPTION	CODE REFERENCE	REQUIREMENT	PROPOSED
<u>GENERAL</u>			
CONSTRUCTION TYPE	TABLE 601	---	TYPE 5A
NO. STORIES		---	3 (EXISTING)

Signage Schedule

Type Mark	Count	Description
	1	Existing awning above entry to be removed
AW-1	3	Sunbrella awning on black ptd metal frame. Open sides.
SG-1	2	Routed MDF "Vinny's on 5mm Dibond with 1"x2" ptd green frame.
SG-2	1	Existing blade sign; refurbish internal lighting; paint supports black.

DEREK RUBINOFF ARCHITECT

11 Sherwood Street #2, Roslindale, MA 02131-3729 617-504-2599 drubinoﬀ@derekubinoﬀ.com

Project Directory & Schedule


Vinny's Ristorante
76 Broadway
Somerville, MA 02145

JOB #: 1122
SCALE: 1/4" = 1'-0"
DATE: 10/14/2011
DWN BY: Author
CROSS REF:

A0.1

RECEIVED
S.P.C.D. AND
PLANNING DEPT.

2011 NOV 30 PM 12:18

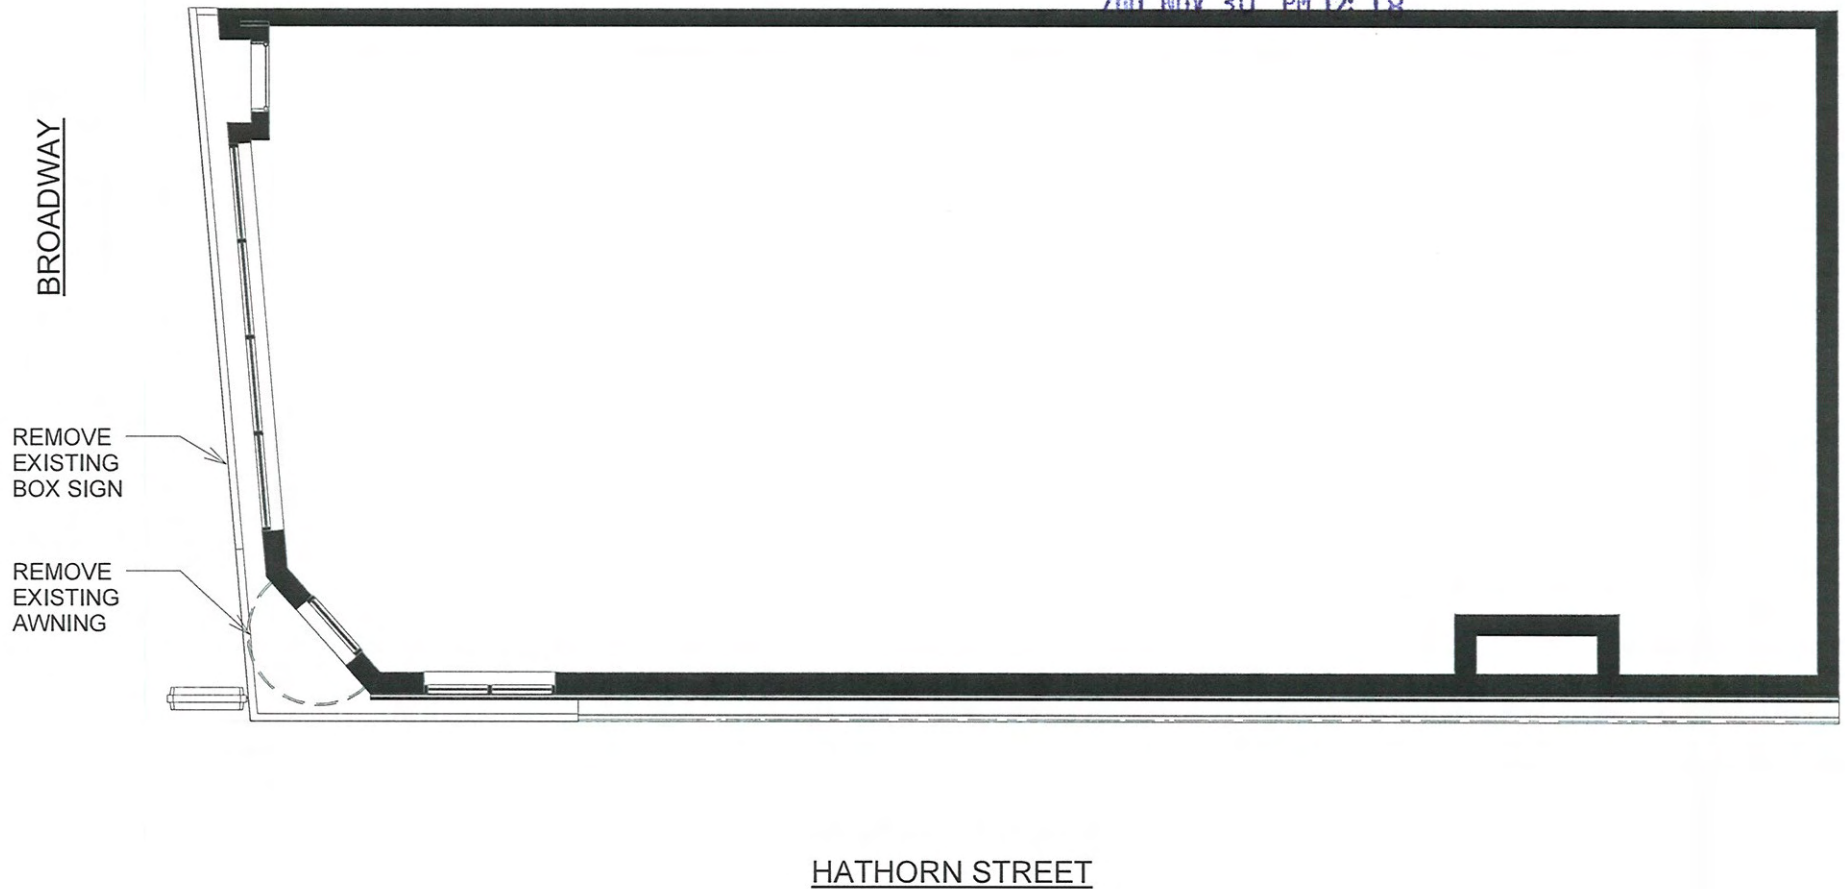

DEREK RUBINOFF ARCHITECT

11 Sherwood Street #2, Roslindale, MA 02131-3729 617-504-2599 drubinoff@derek-rubinoff.com

Demolition RCP

Vinny's Ristorante


76 Broadway
Somerville, MA 02145

JOB #:	1122
SCALE:	1/8" = 1'-0"
DATE:	10/14/2011
DWN BY:	Author
CROSS REF:	

A0.2

RECEIVED
S.P.C.D. AND
PLANNING DEPT.

2011 NOV 30 PM 12:18

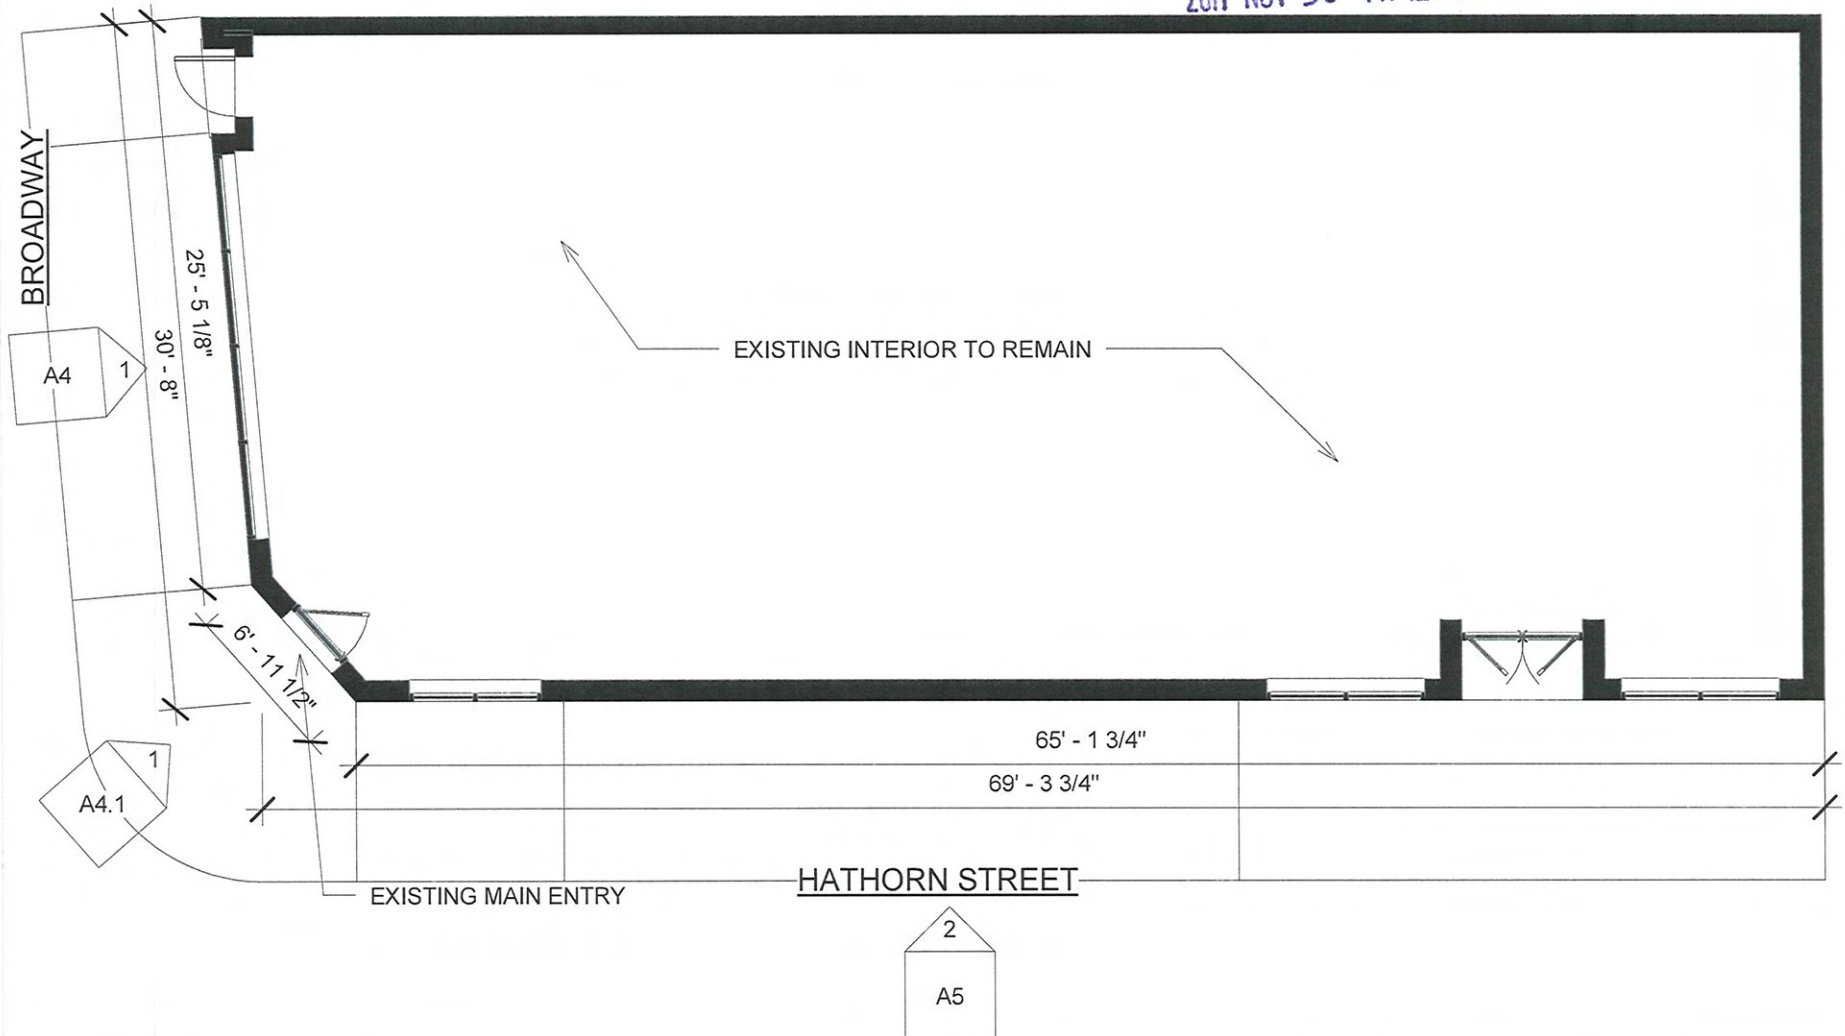

DEREK RUBINOFF ARCHITECT

11 Sherwood Street #2, Roslindale, MA 02131-3729 617-504-2599 drubinoff@derek-rubinoff.com

First Floor

Vinny's Ristorante


76 Broadway
Somerville, MA 02145

JOB #:	1122
SCALE:	1/8" = 1'-0"
DATE:	10/14/2011
DWN BY:	Author
CROSS REF:	

A1

RECEIVED
S.P.C.D. AND
PLANNING DEPT.

2011 NOV 30 PM 12:16

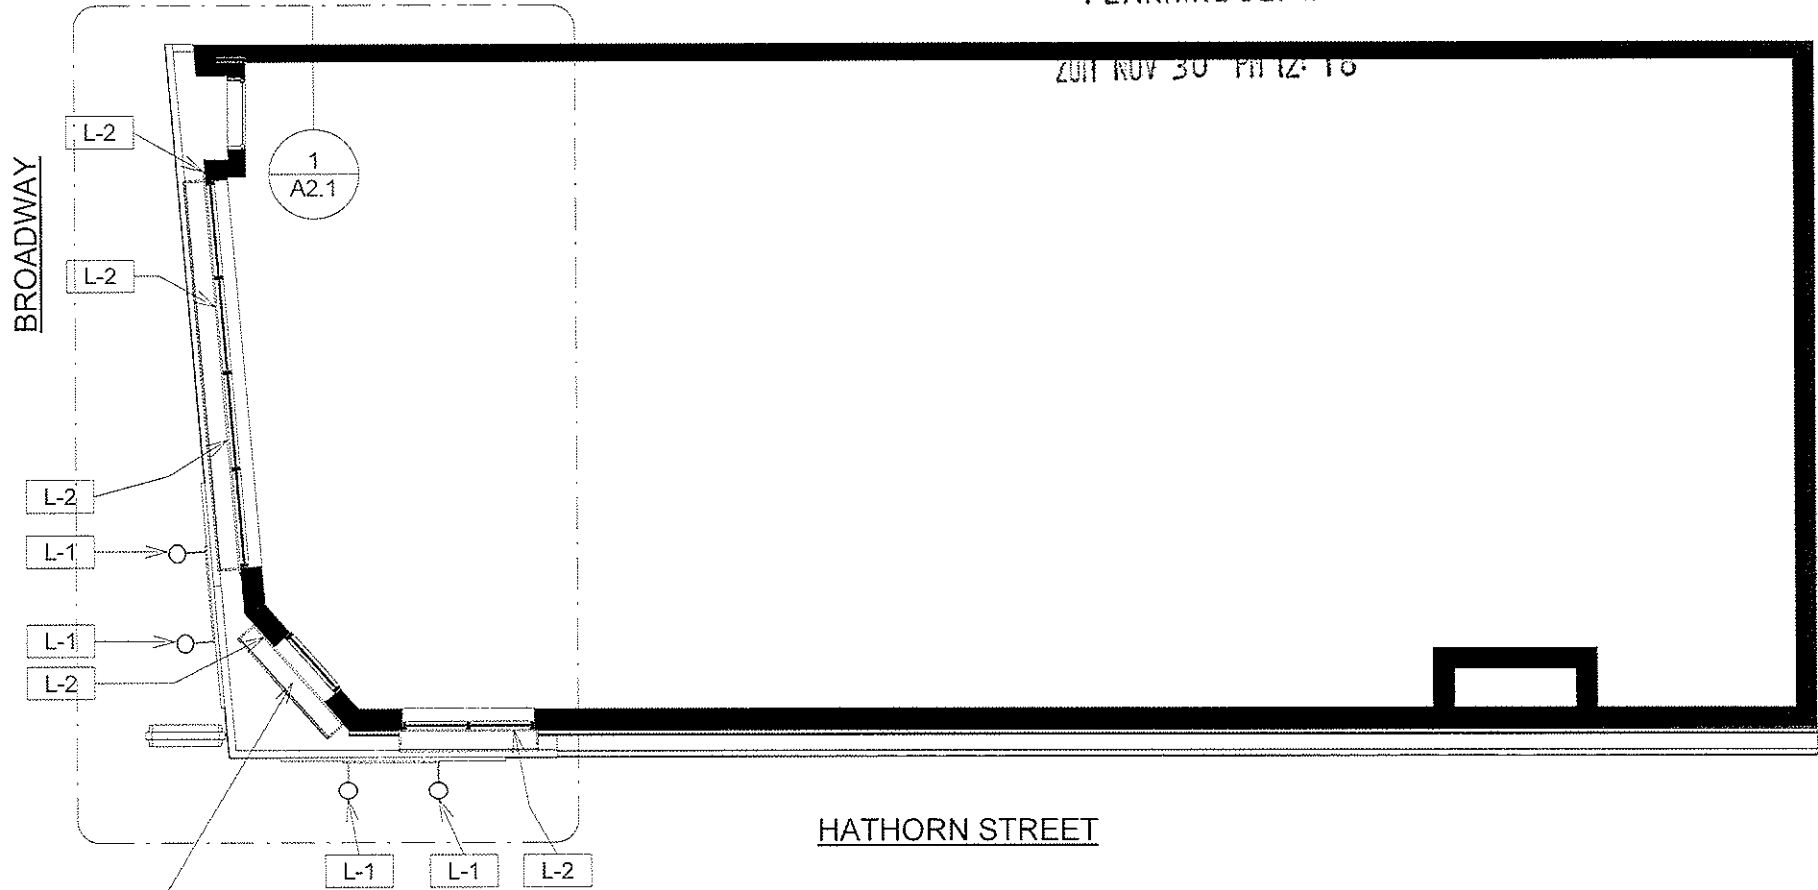

Lighting Fixture Schedule								
Type Mark	Count	Description	Manufacturer	Model	Lamp	Wattage	Initial Color Temperature	Type Comments
L-1	4	Sign Light	PHILIPS	XX	X	42 W	3000 K	
L-2	5	LED strip			LED	40 W	3000 K	Mount thin strip to underside of soffit

DEREK RUBINOFF ARCHITECT

11 Sherwood Street #2, Roslindale, MA 02131-3729 617-504-2599 drubinoff@derekubinoff.com

First Floor Reflected Ceiling Plan

Vinny's Ristorante

76 Broadway
Somerville, MA 02145


JOB # 1122
SCALE 1/8" = 1'-0"
DATE 10/14/2011
DWN BY Author
CROSS REF:

A2

RECEIVED
S.P.C.D. AND
PLANNING DEPT.

2011 NOV 30 PM 12:18

BROADWAY

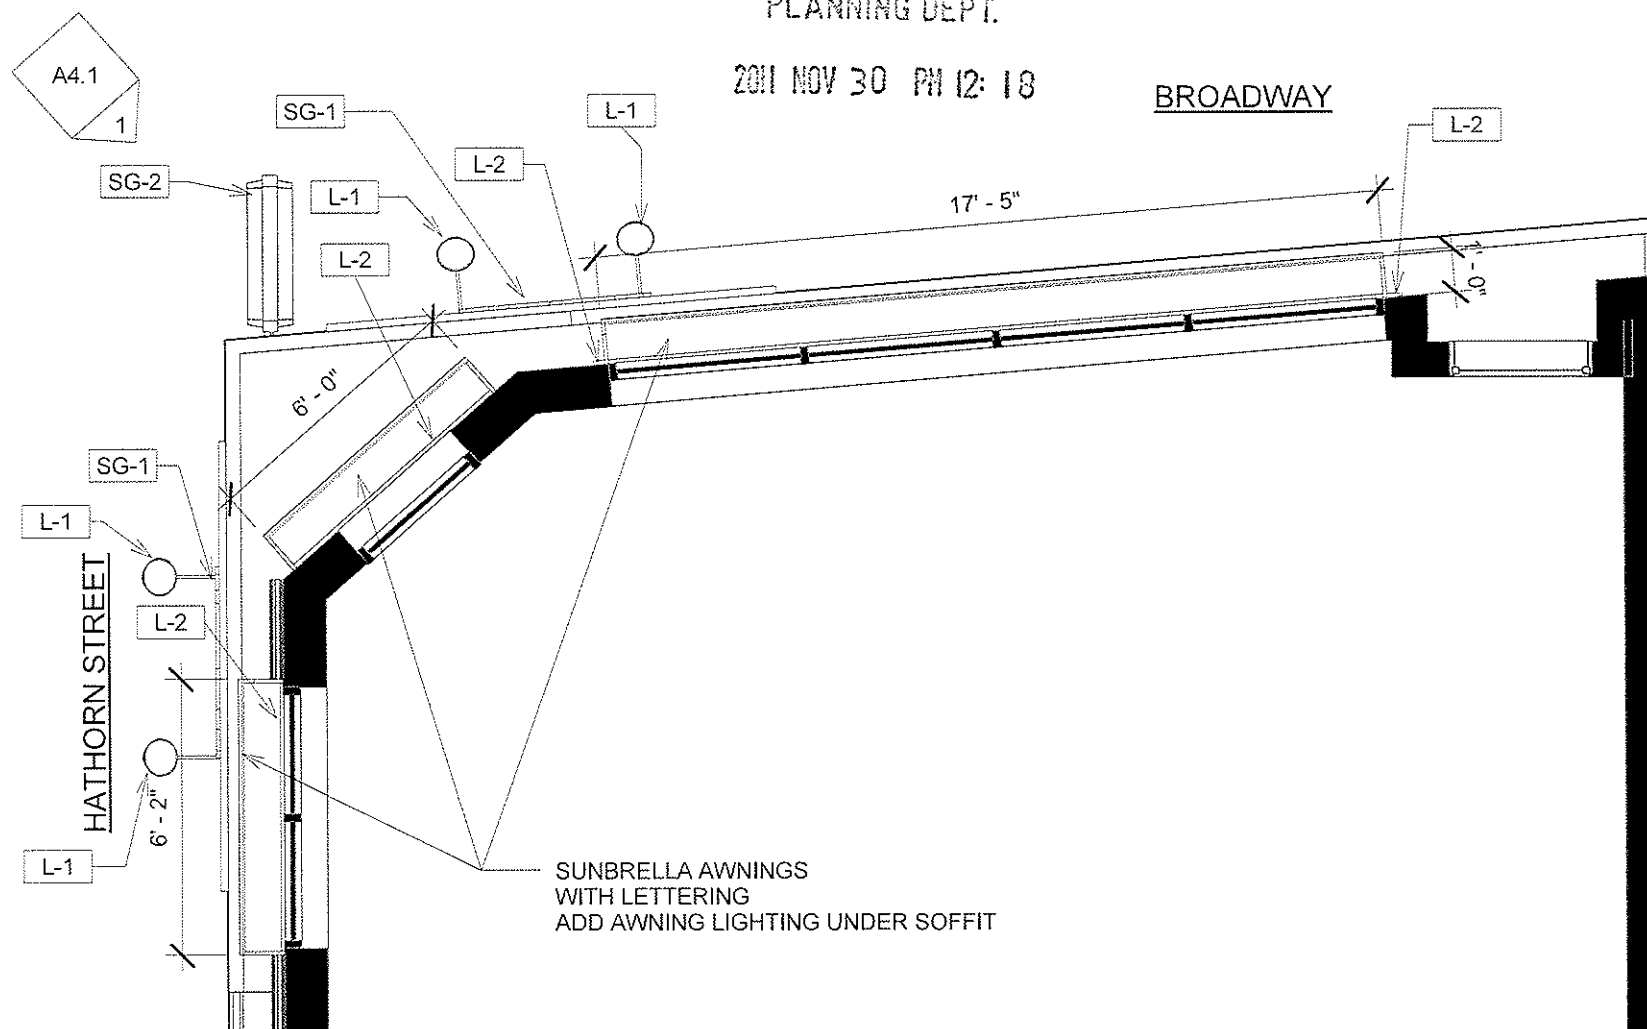

1 Callout of RCP
1/4" = 1'-0"

SUNBRELLA AWNINGS
WITH LETTERING
ADD AWNING LIGHTING UNDER SOFFIT

DEREK RUBINOFF ARCHITECT

11 Sherwood Street #2, Roslindale, MA 02131-3729 617-504-2599 drubinoff@derekubinoff.com

Enlarged Ceiling Plan


Vinny's Ristorante
76 Broadway
Somerville, MA 02145

JOB #:	1122
SCALE:	1/4" = 1'-0"
DATE:	10/14/2011
DWN BY:	Author
CROSS REF:	

A2.1

RECEIVED
S.P.C.D. AND
PLANNING DEPT.

2011 NOV 30 PM 12: 18

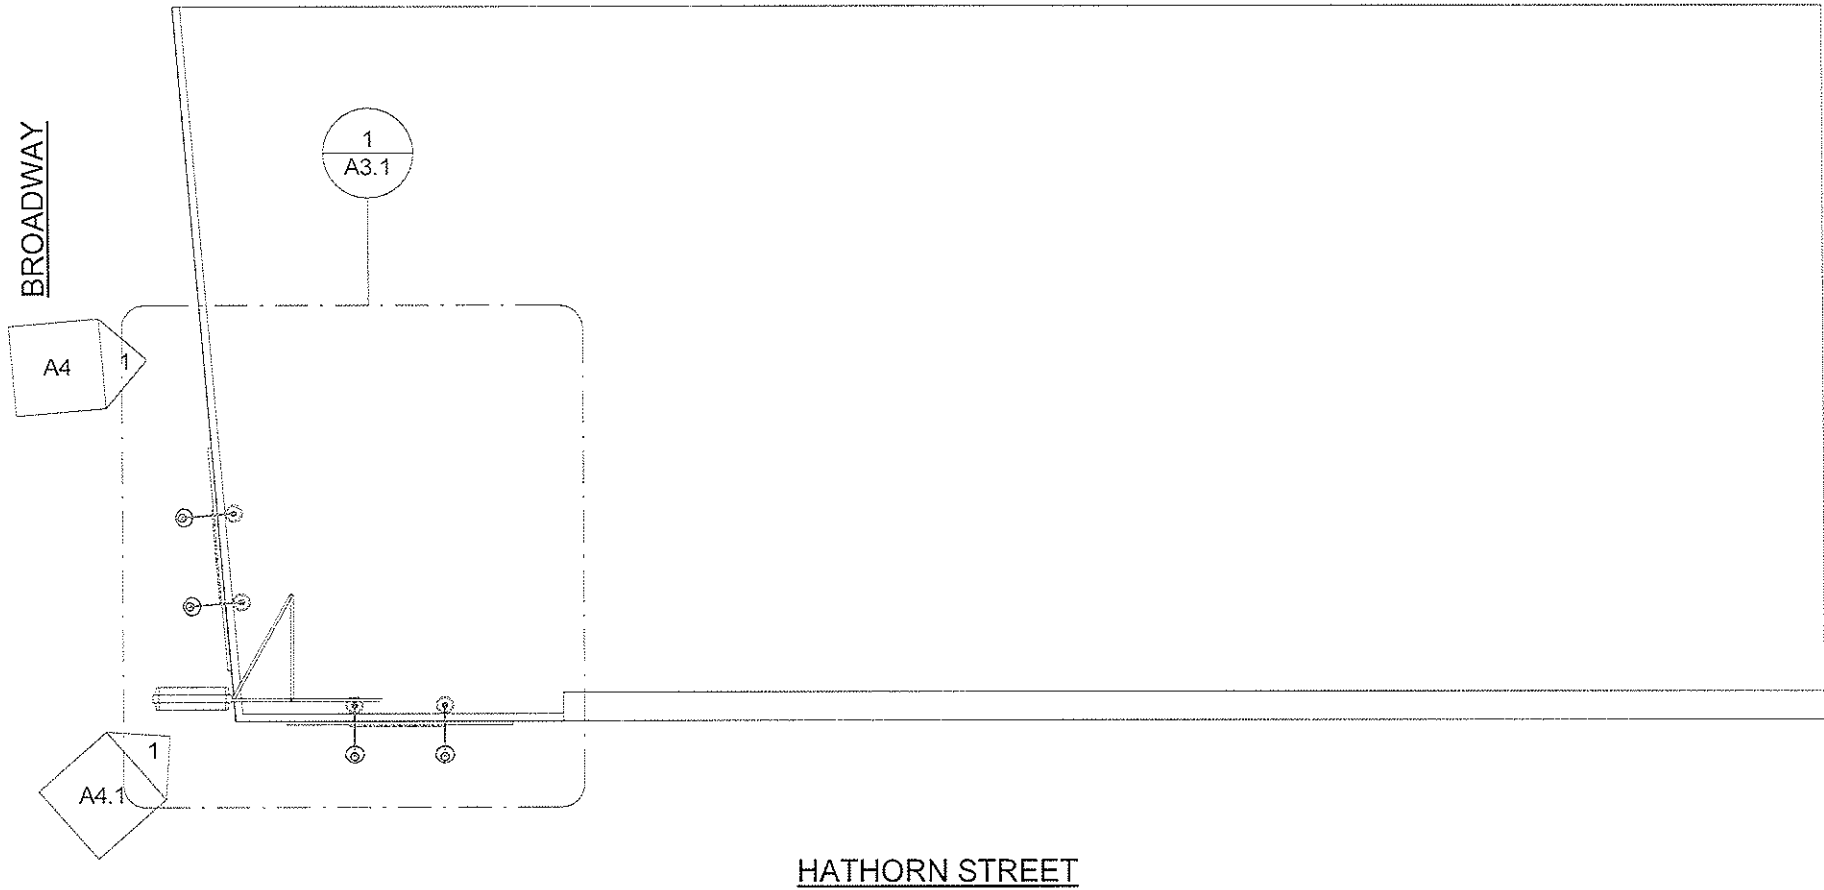

DEREK RUBINOFF ARCHITECT

11 Sherwood Street #2, Roslindale, MA 02131-3729 617-504-2599 drubinoff@derek Rubinoff.com

Roof Plan

Vinny's Ristorante


76 Broadway
Somerville, MA 02145

JOB #:	1122
SCALE:	1/8" = 1'-0"
DATE:	10/14/2011
DWN BY:	Author
CROSS REF:	

A3

RECEIVED
S.P.C.D. AND
PLANNING DEPT.

2011 NOV 30 PM 12:18

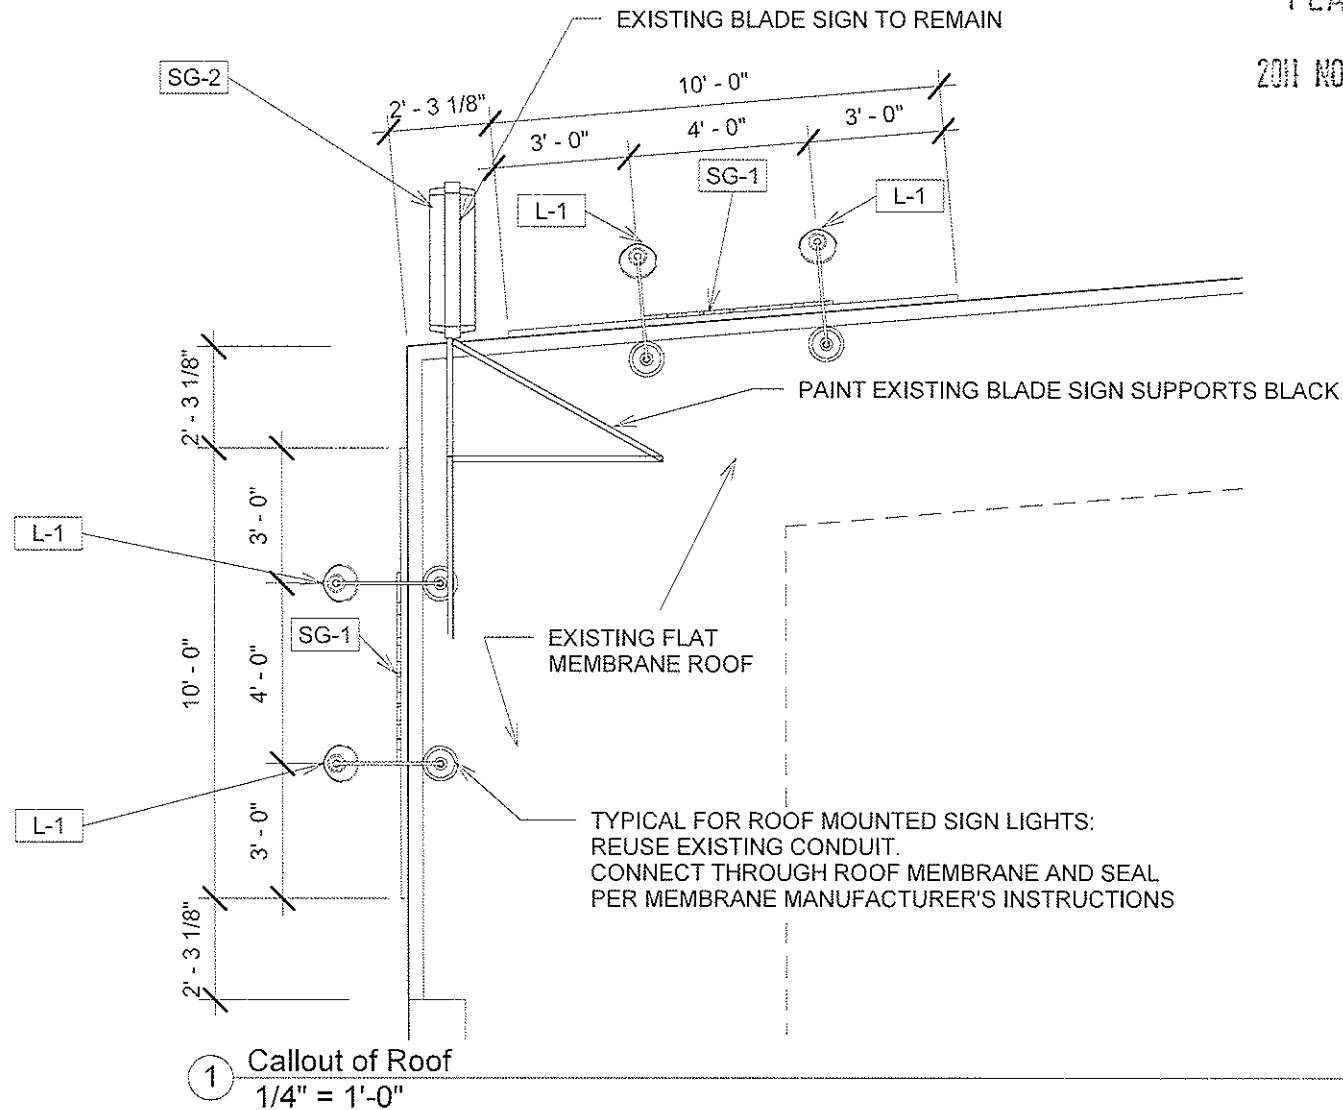

DEREK RUBINOFF ARCHITECT

11 Sherwood Street #2, Roslindale, MA 02131-3729 617-504-2599 drubinoff@derek-rubinoff.com

Roof Plan Call Out


Vinny's Ristorante
76 Broadway
Somerville, MA 02145

JOB #:	1122
SCALE:	1/4" = 1'-0"
DATE:	10/14/2011
DWN BY:	Author
CROSS REF:	

A3.1

RECEIVED
S.P.C.D. AND
PLANNING DEPT.

2011 NOV 30 PM 12:18

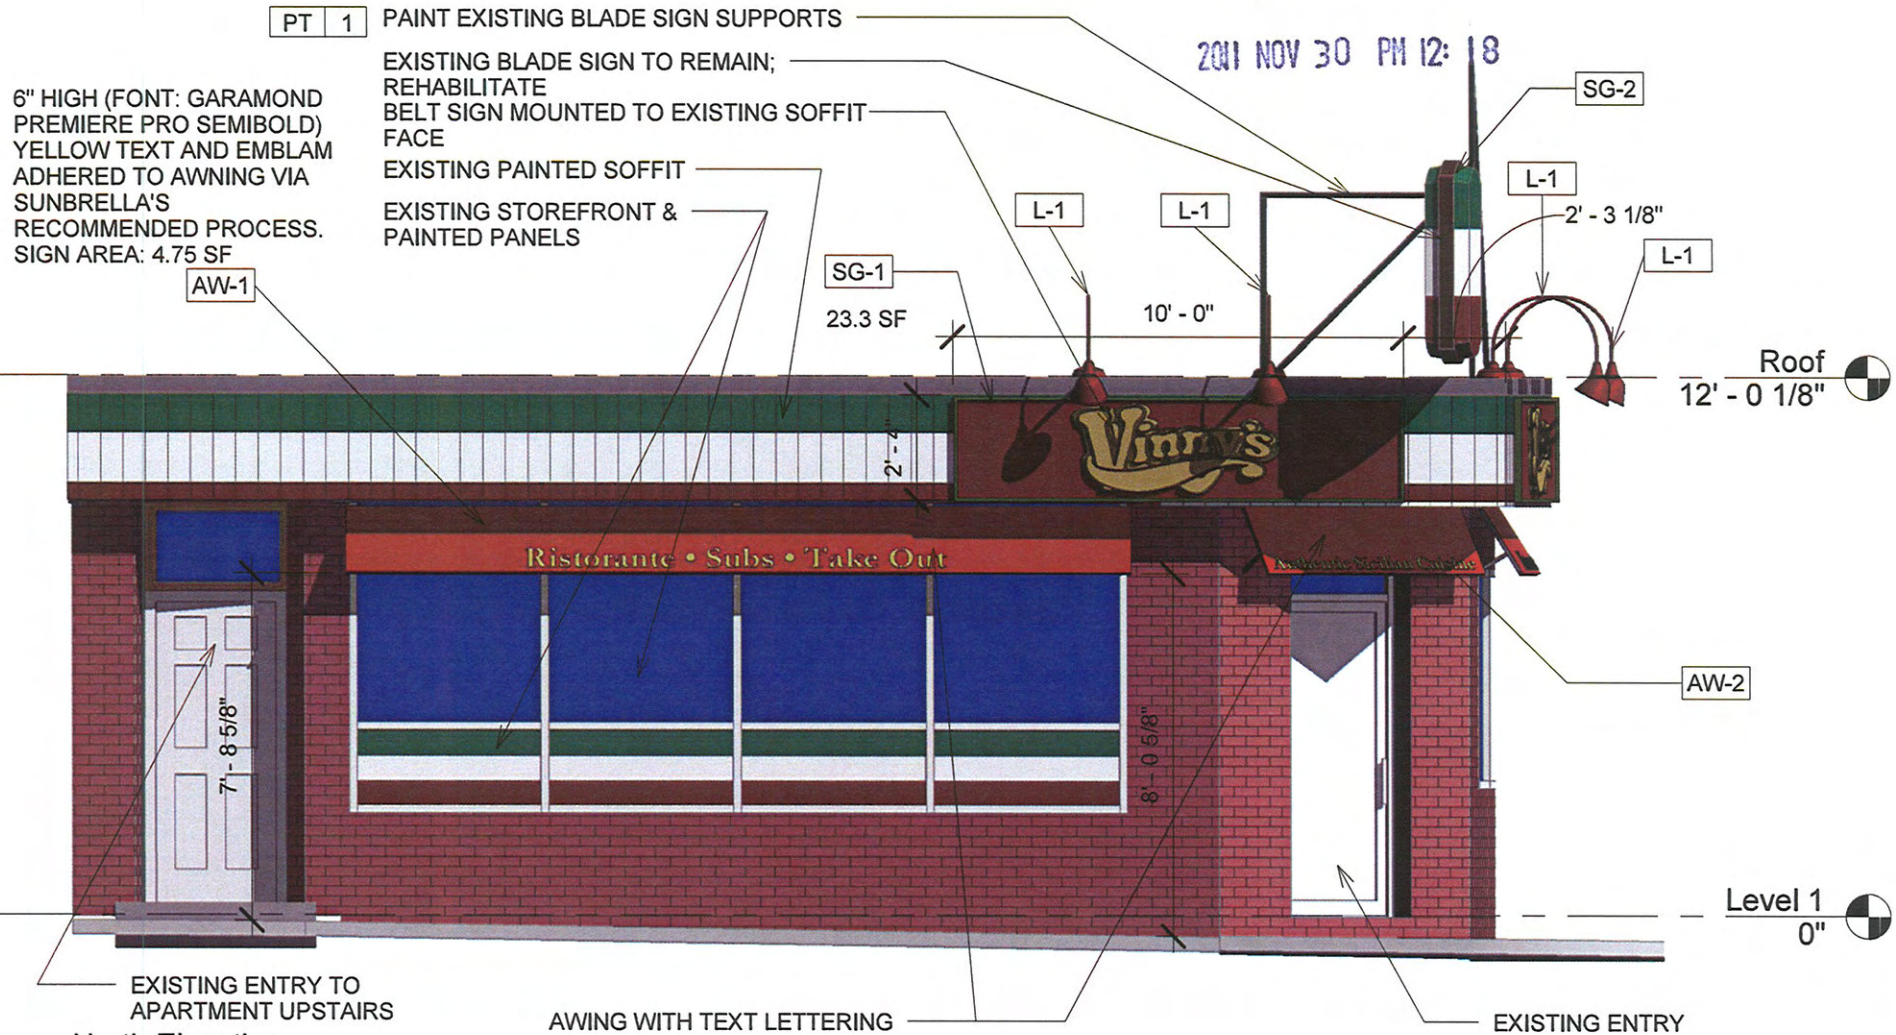

1 North Elevation
1/4" = 1'-0"

DEREK RUBINOFF ARCHITECT

11 Sherwood Street #2, Roslindale, MA 02131-3729 617-504-2599 drubinoff@derekubinoff.com

North Elevation


Vinny's Ristorante
76 Broadway
Somerville, MA 02145

JOB #: 1122
SCALE: 1/4" = 1'-0"
DATE: 10/14/2011
DWN BY: Author
CROSS REF:

A4

RECEIVED
S.P.C.D. AND
PLANNING DEPT.

2011 NOV 30 PM 12: 18

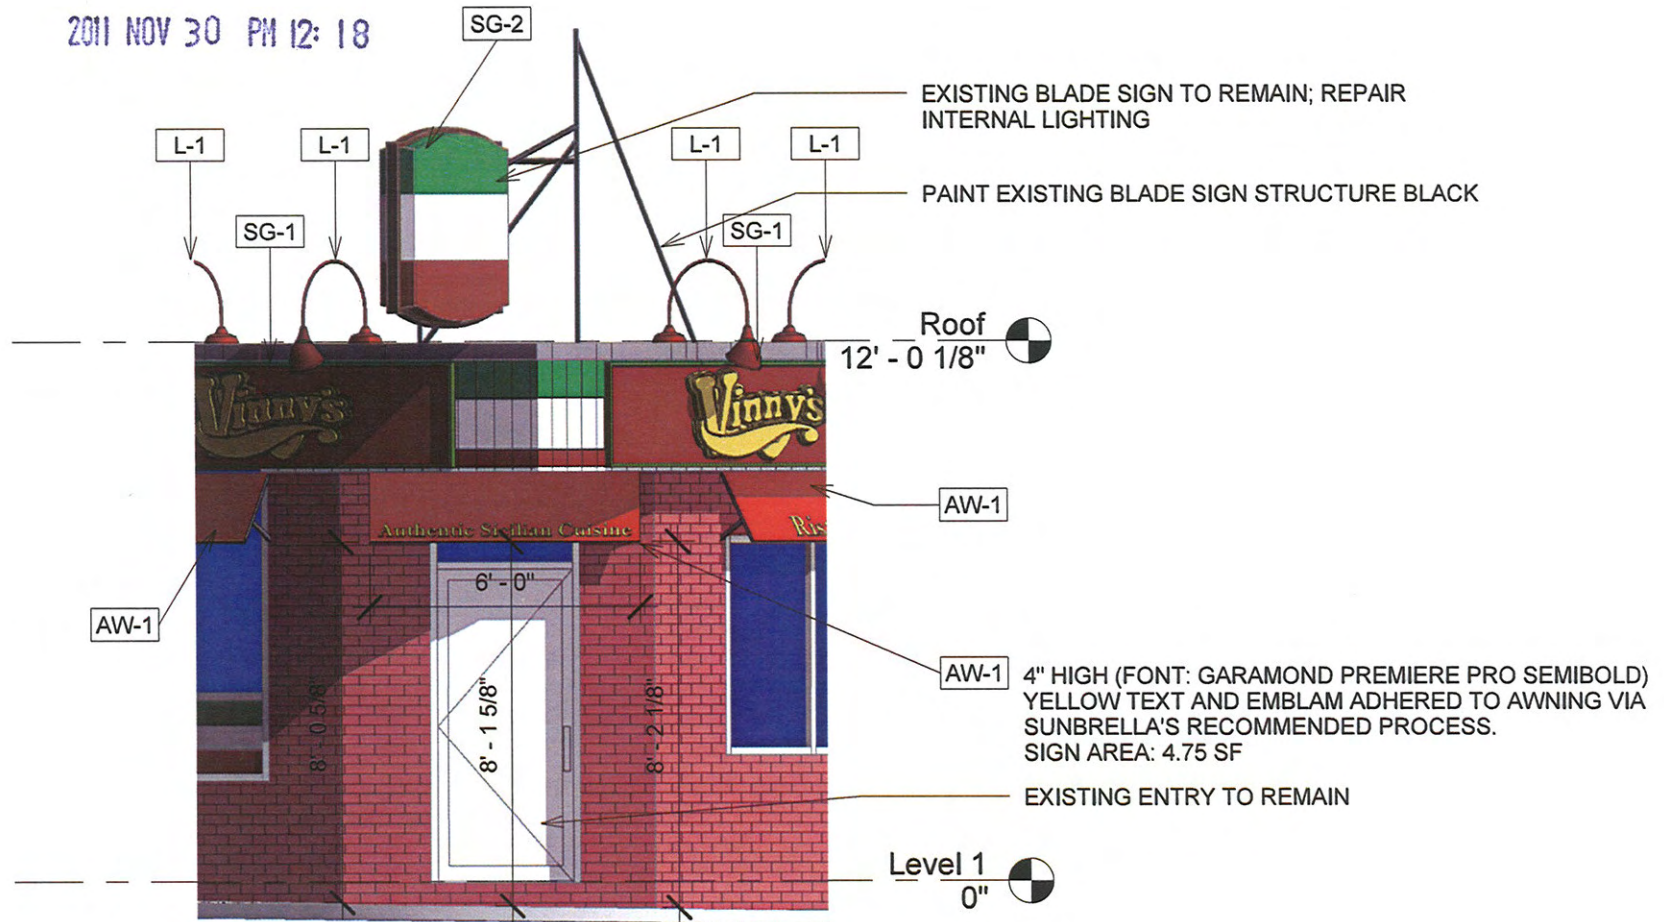

1 Entry Elevation
1/4" = 1'-0"

DEREK RUBINOFF ARCHITECT

11 Sherwood Street #2, Roslindale, MA 02131-3729 617-304-2597 d Rubinoff@derek Rubinoff.com

Entry Elevation


Vinny's Ristorante
76 Broadway
Somerville, MA 02145

JOB #:	1122
SCALE:	1/4" = 1'-0"
DATE:	10/14/2011
DWN BY:	Author
CROSS REF:	

A4.1

RECEIVED
S.P.C.D. AND
PLANNING DEPT.

2011 NOV 30 PM 12:18

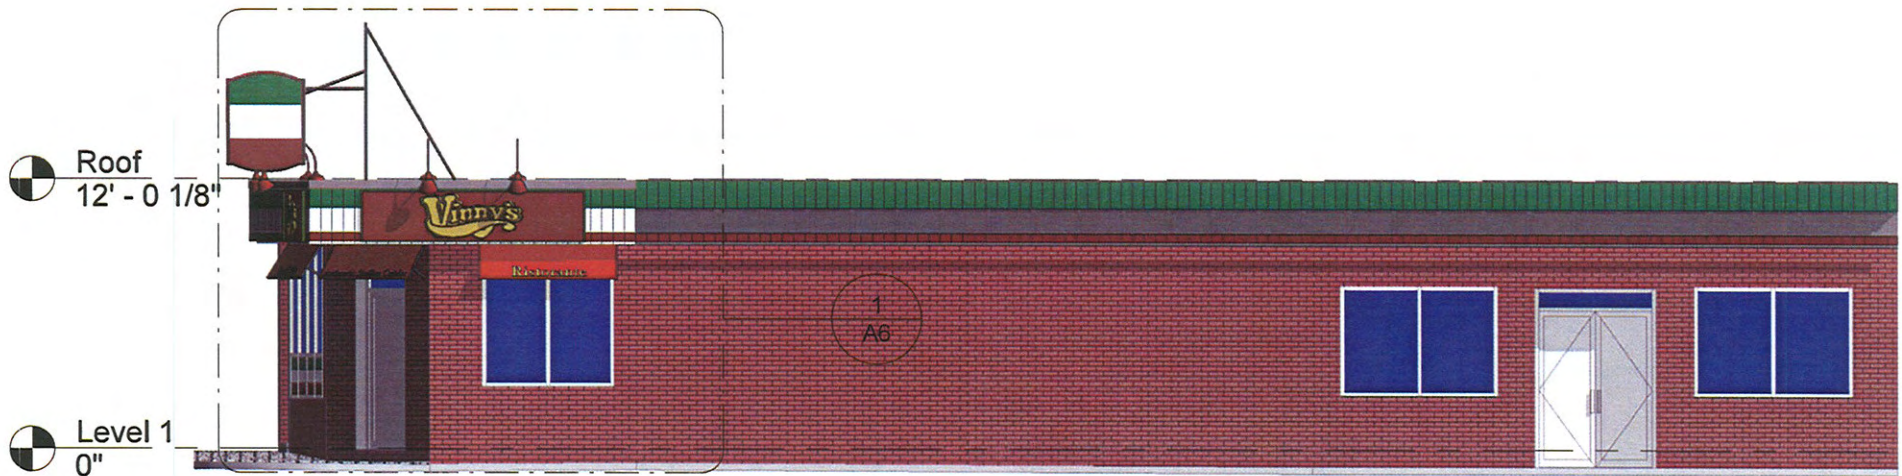

② West
1/8" = 1'-0"

DEREK RUBINOFF ARCHITECT

11 Sherwood Street #2, Roslindale, MA 02131-3729 617-504-2599 drubinoff@derek Rubinoff.com

West Elevation

Vinny's Ristorante


76 Broadway
Somerville, MA 02145

JOB #:	1122
SCALE:	1/8" = 1'-0"
DATE:	10/14/2011
DWN BY:	Author
CROSS REF:	

A5

RECEIVED
S.P.C.D. AND
PLANNING DEPT.

2011 NOV 30 PM 12:18

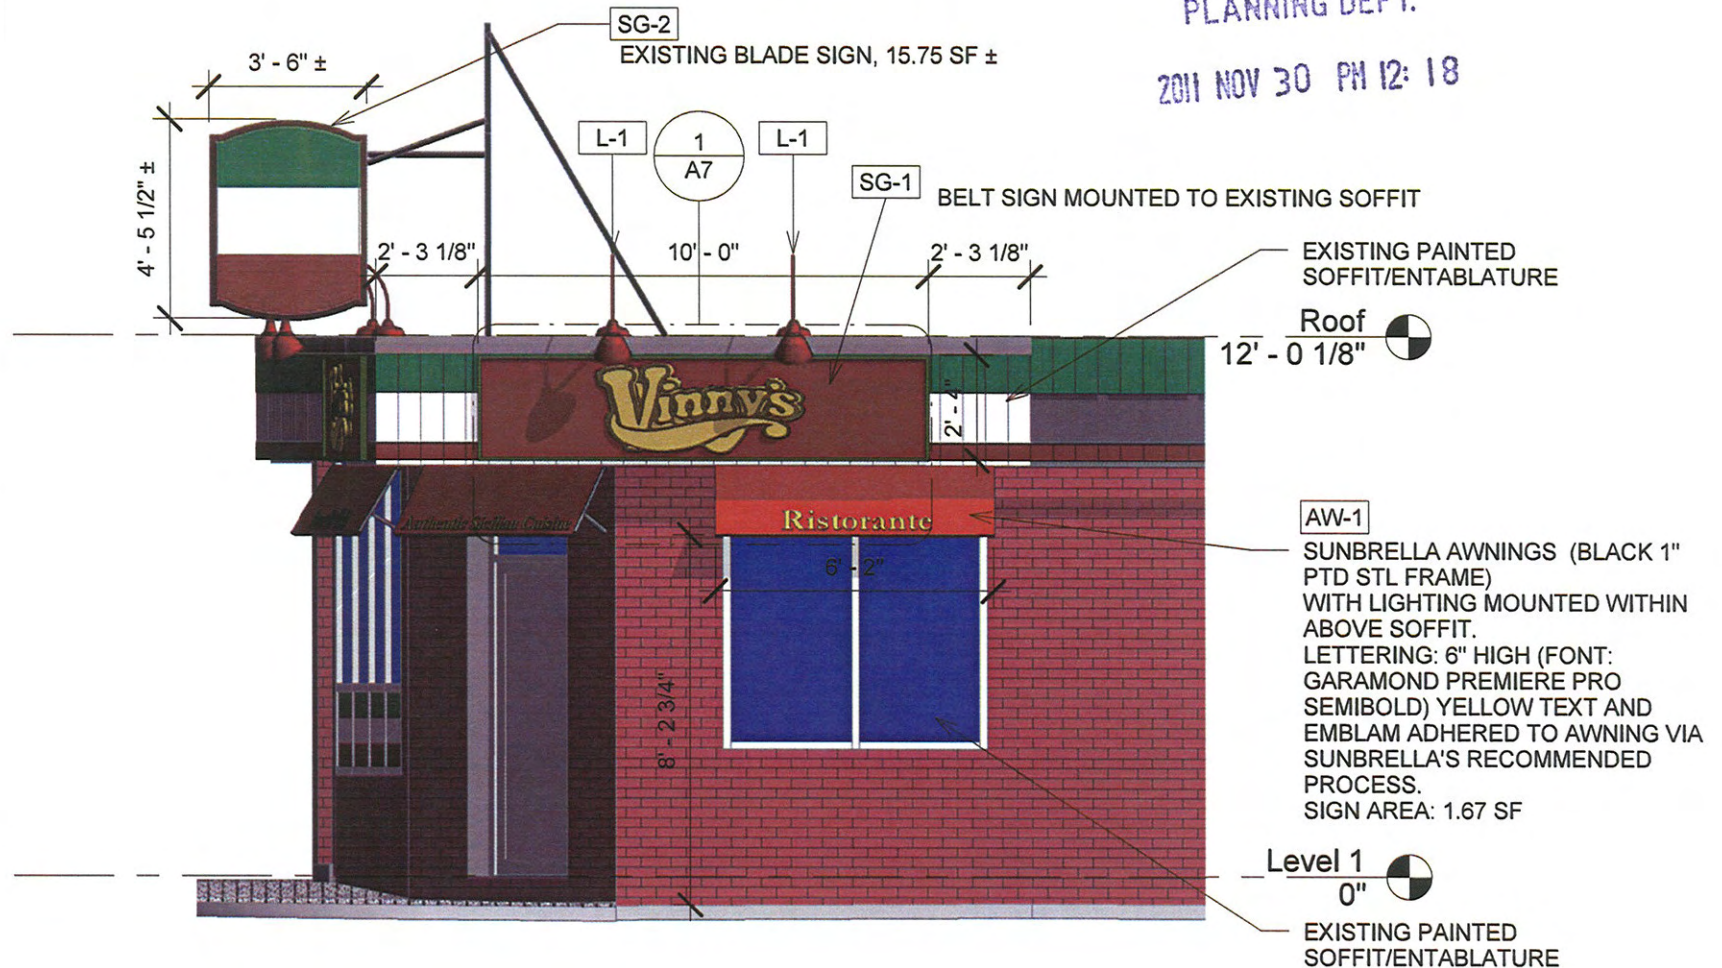

1 Callout of West
1/4" = 1'-0"

DEREK RUBINOFF ARCHITECT

11 Sherwood Street #2, Roslindale, MA 02131-3729 617-504-2599 d.rubinoff@derekubinoff.com

West Elevation--Call Out

Vinny's Ristorante

76 Broadway
Somerville, MA 02145

JOB #:	1122
SCALE:	1/4" = 1'-0"
DATE:	10/14/2011
DWN BY:	Author
CROSS REF:	

A6

RECEIVED
S.P.C.D. AND
PLANNING DEPT.

2011 NOV 30 PM 12: 18

10' - 0"

1
A7.1

SG-1

RED GRAPHIC ON 5MM DIBOND

1" X 2" ALUM FRAME PTD GREEN

Roof

12' - 0 1/8"

4' - 7"

2' - 0 1/2"

Vinny's

Sicilian Cuisine

1' - 6 1/8"

Ristorante

① Sign Detail
1" = 1'-0"

ROUTED MDF PTD LOGO SIGN MOUNTED TO DIBOND BACKER WITH
NO VISIBLE FASTENERS

DEREK RUBINOFF ARCHITECT

11 Sherwood Street #2, Roslindale, MA 02131-3729 617-504-2599 drubinoff@derek Rubinoff.com

Details

Vinny's Ristorante


76 Broadway
Somerville, MA 02145

JOB #:	1122
SCALE:	1" = 1'-0"
DATE:	10/14/2011
DWN BY:	Author
CROSS REF:	


A7

RECEIVED
S.P.C.D. AND
PLANNING DEPT.

2011 NOV 30 PM 12:18

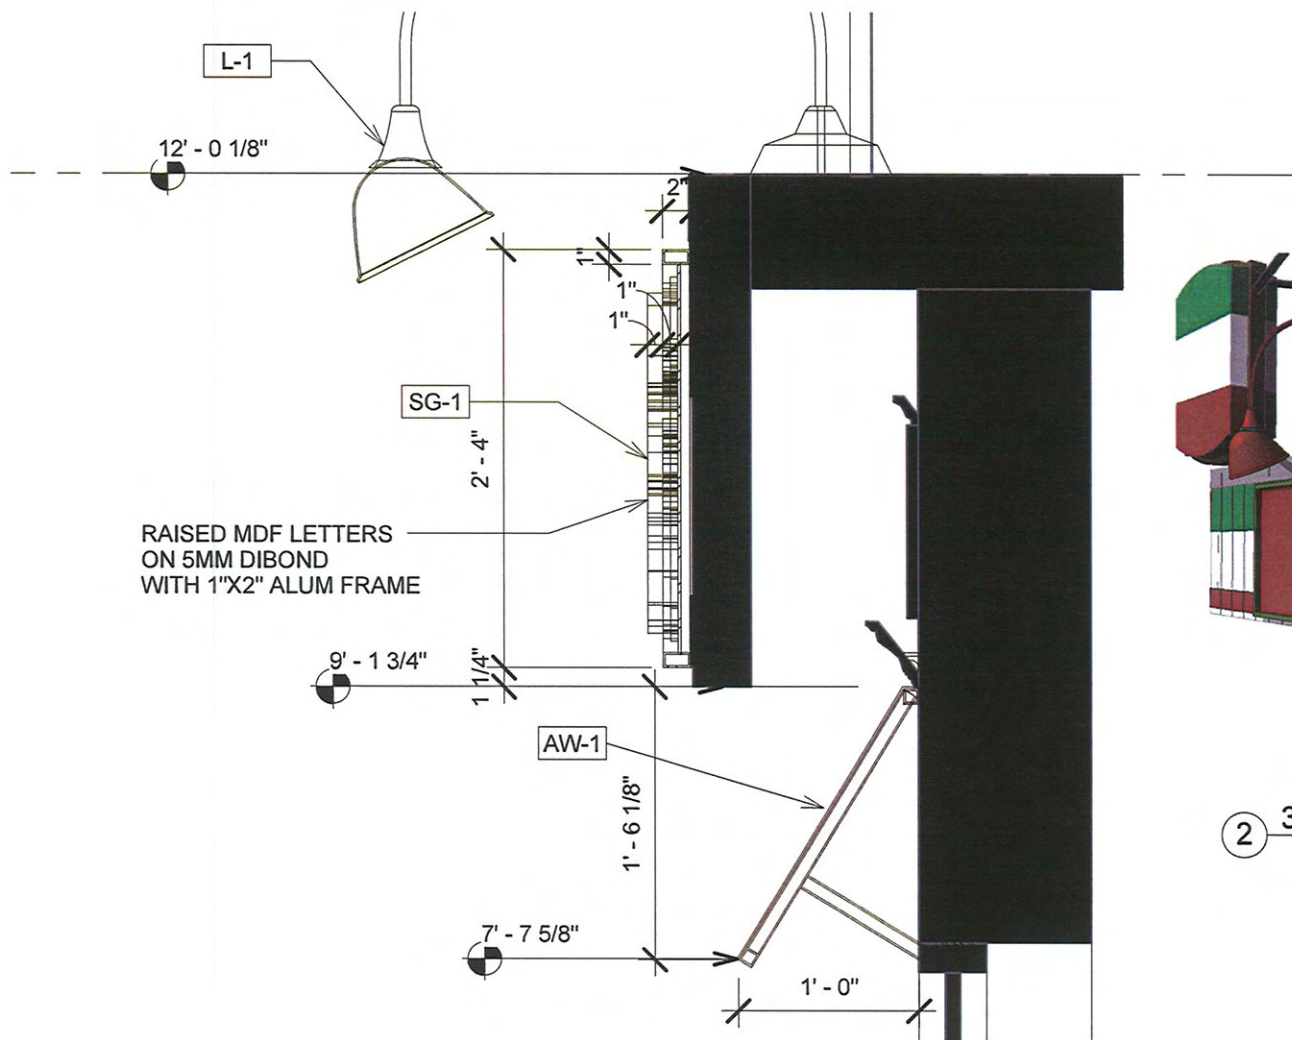

1 Sign Section
1" = 1'-0"

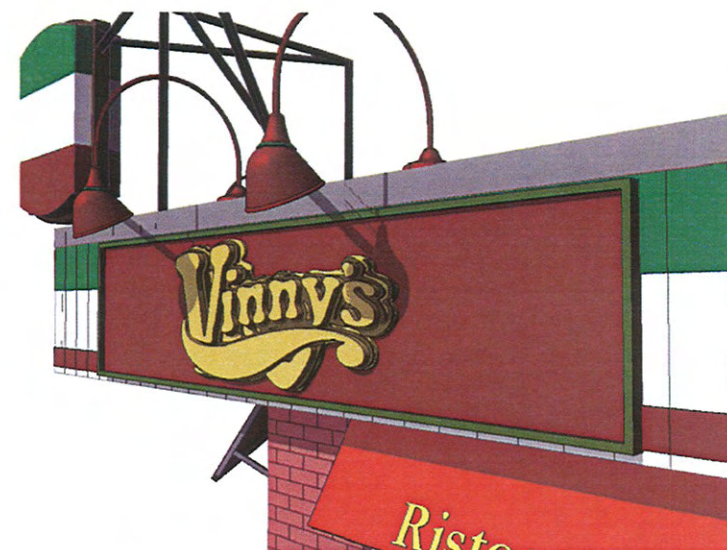

2 3D View of Belt Sign

DEREK RUBINOFF ARCHITECT

11 Sherwood Street #2, Roslindale, MA 02131-3723 617-504-2599 drubinoff@derekubinoff.com

Details

Vinny's Ristorante

76 Broadway
Somerville, MA 02145

JOB #:	1122
SCALE:	1" = 1'-0"
DATE:	10/14/2011
DWN BY:	Author
CROSS REF:	

A7.1