




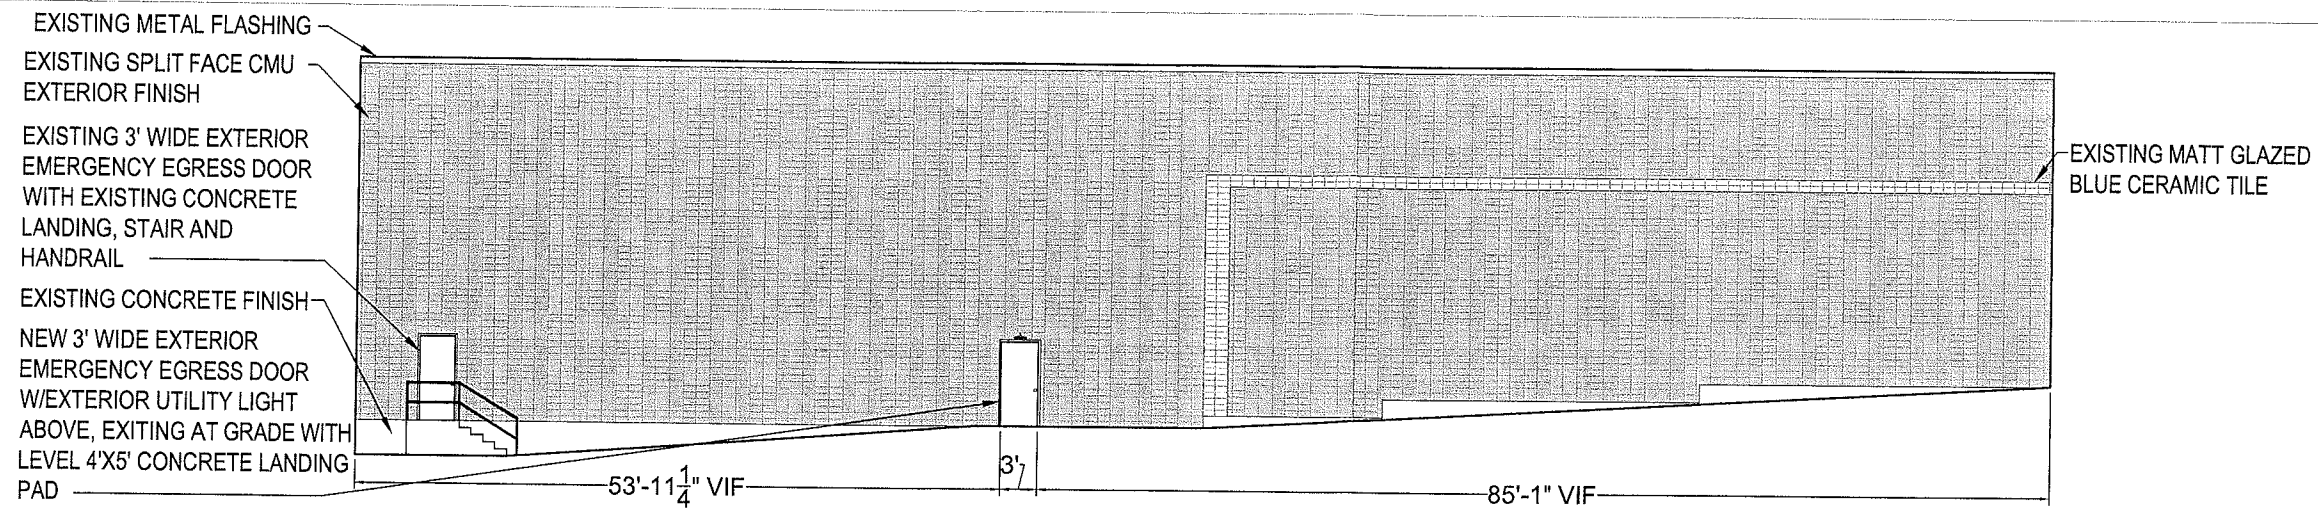

1 WEST ELEVATION
scale: $\frac{1}{16}" = 1'-0"$

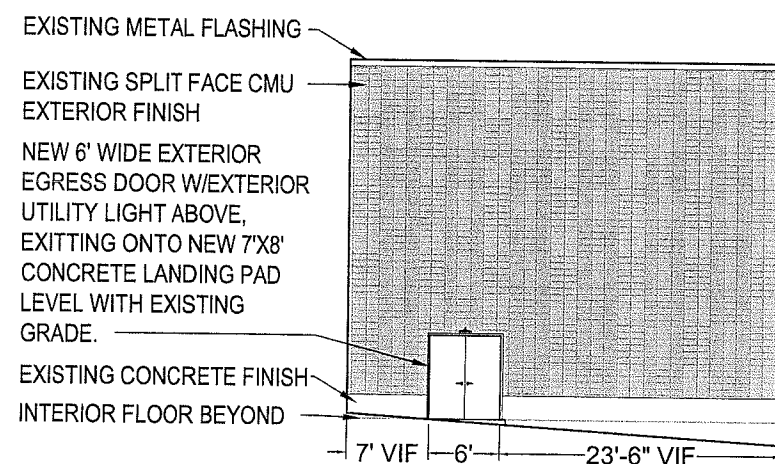

2 SOUTH/EAST ELEVATION
scale: $\frac{1}{16}" = 1'-0"$

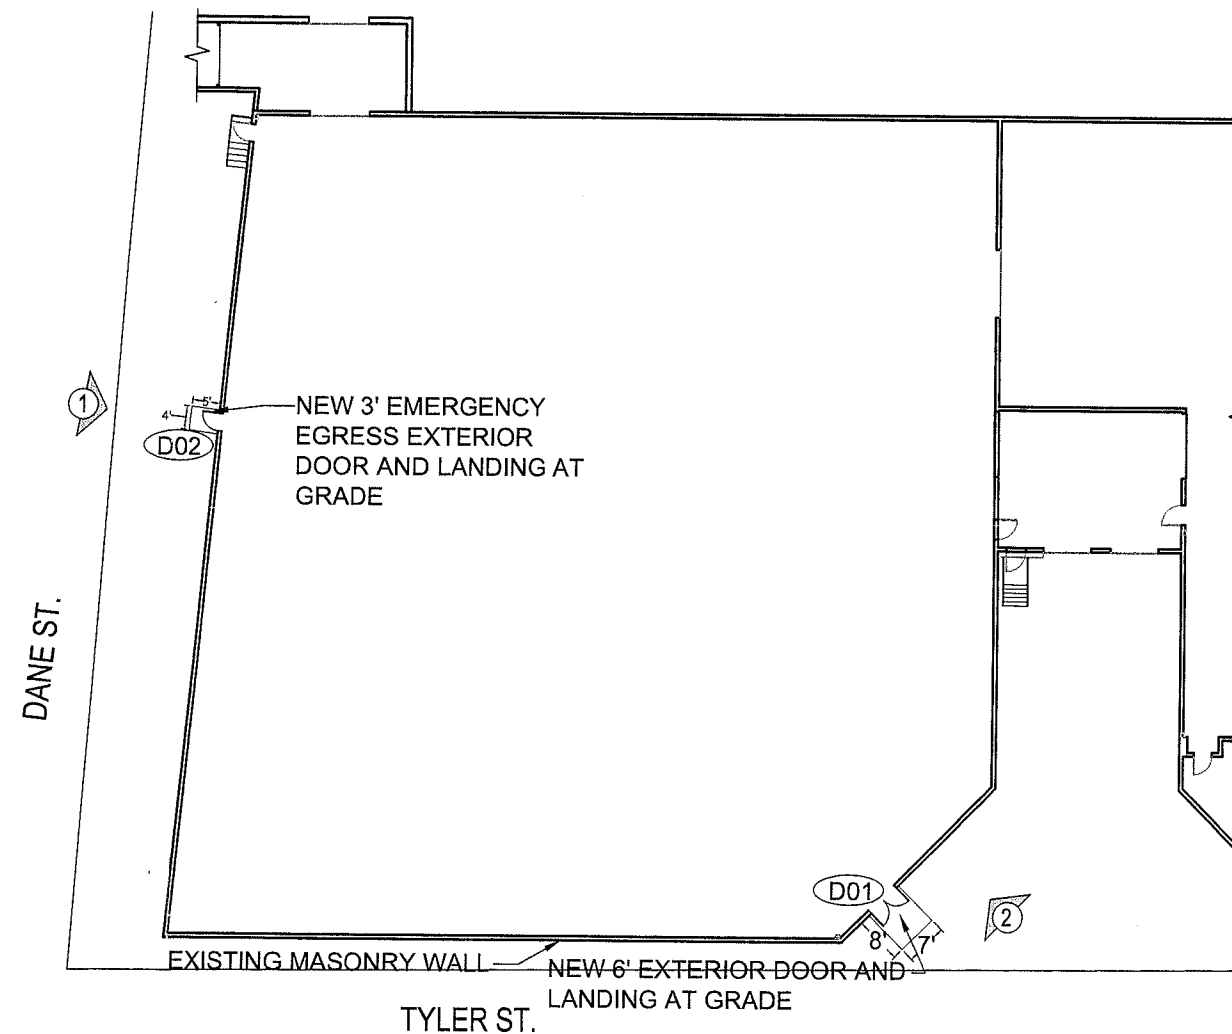


3 DOOR LOCATION PLAN
scale: $\frac{1}{32}" = 1'-0"$

DOOR NO.	DOOR TYPE	SIZE		FRAME	DOOR	DOOR & FRAME FIRE RATING	FINISH	HARDWARE							
		WIDTH	HEIGHT					Hinges - 1.5 pair/door TYP	Lockset	Lockset Finish	Handle	Handle Finish	Trim	Closer	Closer Finish
D01	Double Hinged	6'-0" (pair of 3'-0" doors)	7'-0"	Hollow Metal	Exterior Hollow Metal	1 hour	Painted	Ives 5-BB-1-HW-3.5x3.5-630-NRP	Von Duprin 22-F Rim Fire Exit Device	USSP28	22L-F w 230L	US32D	Knob and Keyed Lock @ Exterior	LCN 4030	USS28
D02	Single Hinged	3'-0"	7'-0"	Hollow Metal	Exterior Hollow Metal	1 hour	Painted	Ives 5-BB-1-HW-3.5x3.5-630-NRP	Von Duprin 22-F Rim Fire Exit Device	USSP28	22K-F w 210K BE	US32D	Knob and Keyed Lock @ Exterior	LCN 4030	USS28

4 DOOR SCHEDULE
scale: NOT TO SCALE

Robert Luchetti Associates, Inc.
17 Properzi Way
Somerville, MA 02143
617 623 7811
617 623 8441 FAX

MIT WAREHOUSE
8 TYLER ST
SOMERVILLE, MA 02143

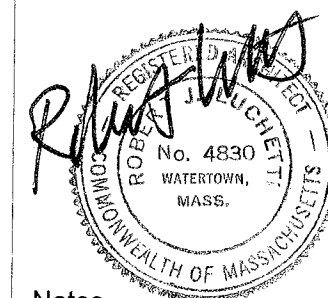






Notes

ELEVATIONS


Date: 10.24.11 Scale: As Noted
Drawn By: RB
Revisions:

A1.0

RCP - Reinforced Concrete Pipe
 CLDI - Cement Lined Ductile Iron
 CI - Cast Iron
 VCT - Vitrified Clay Tile
 ECSS - Existing Combined Sanitary Sewer
 ▼ Thrust Block

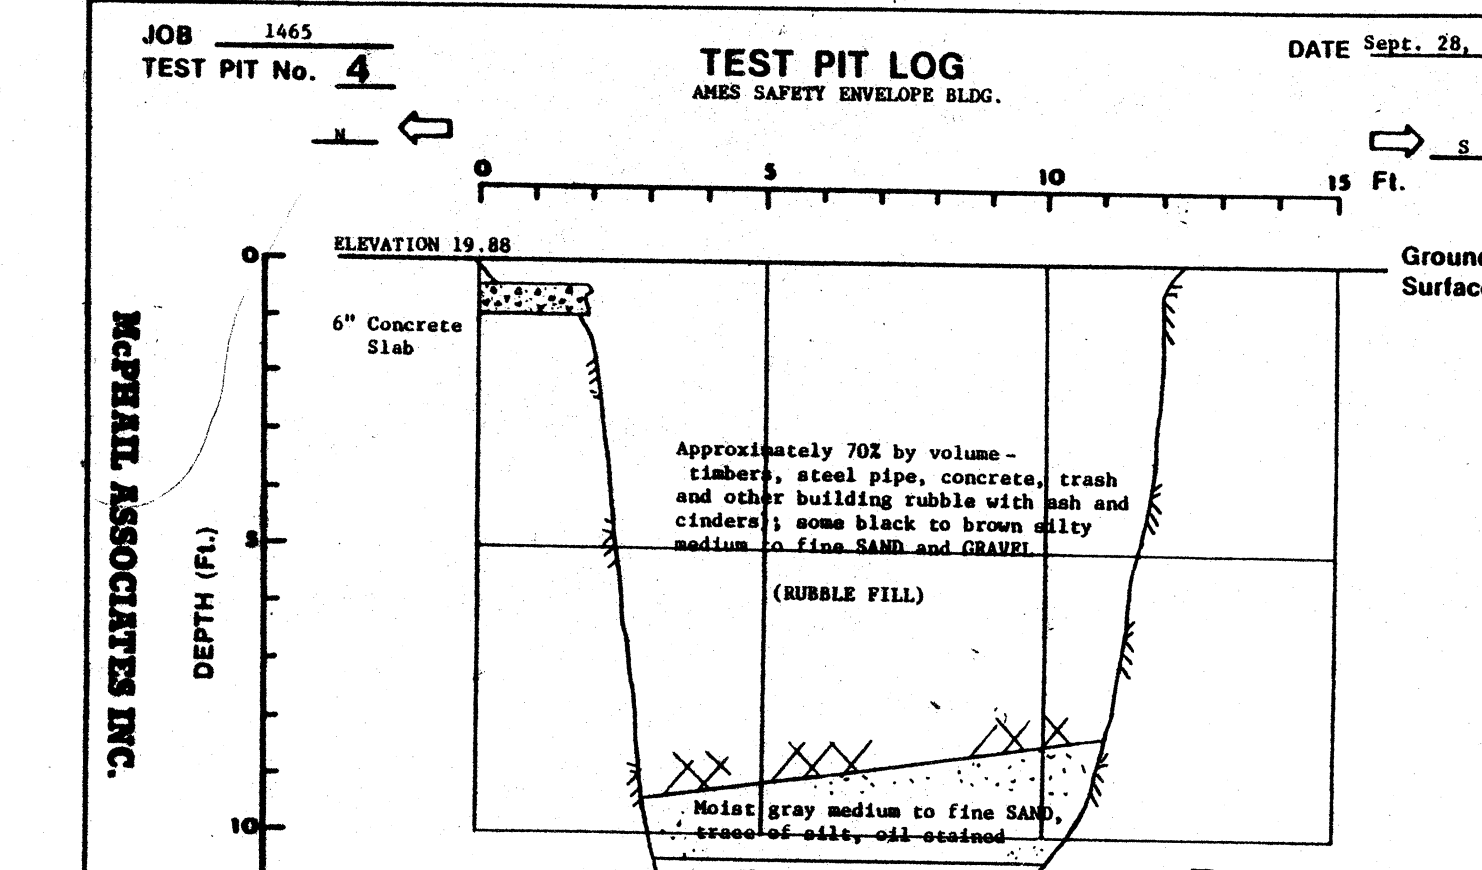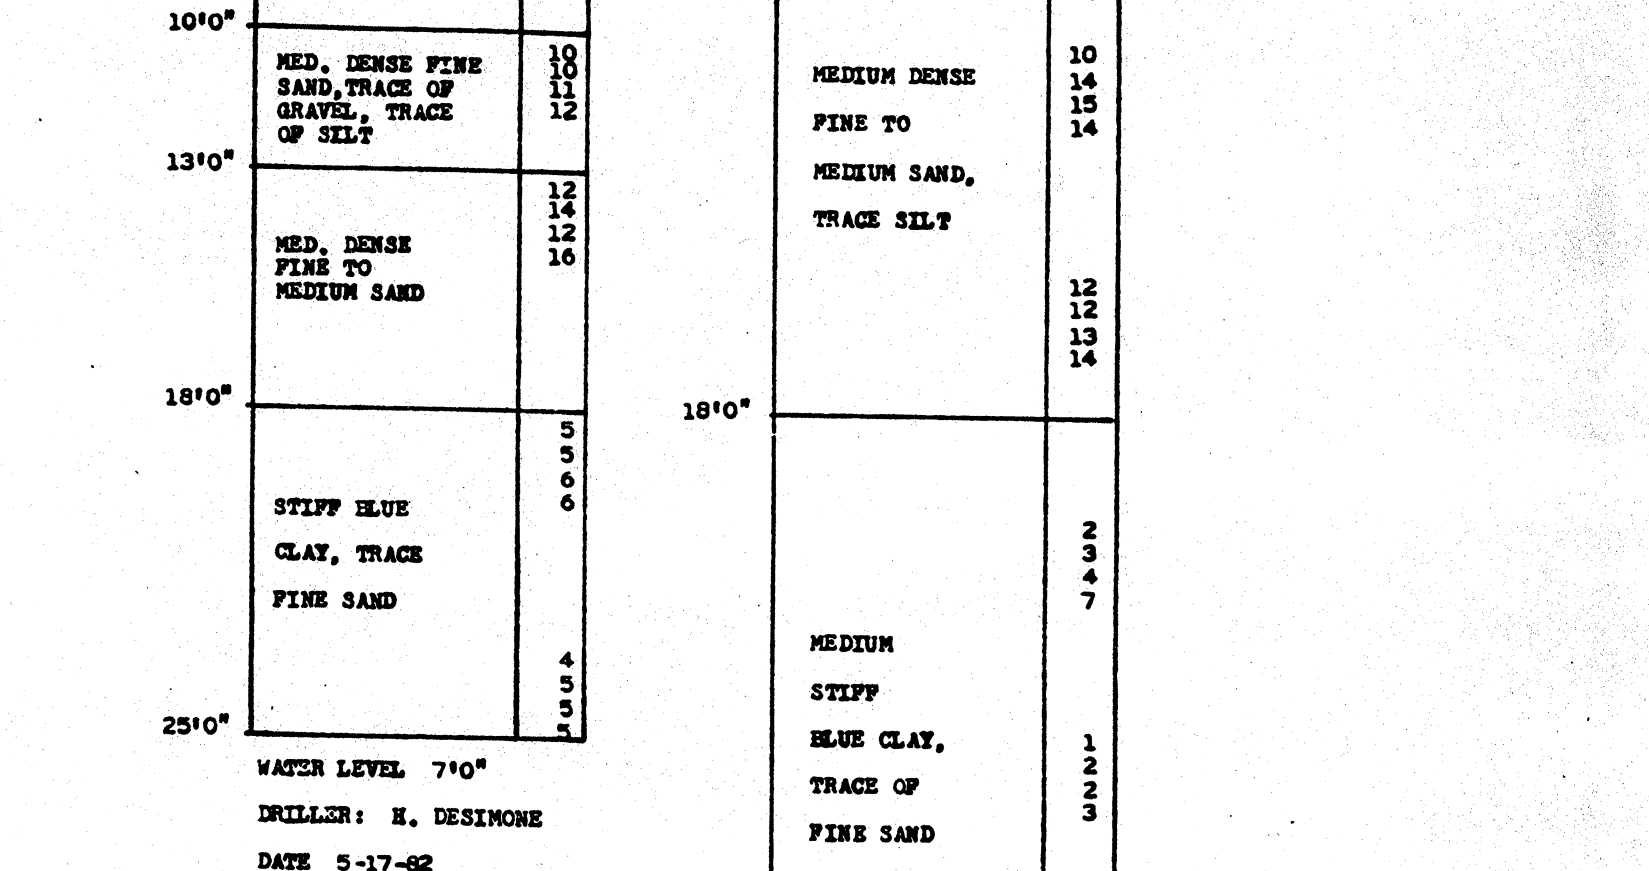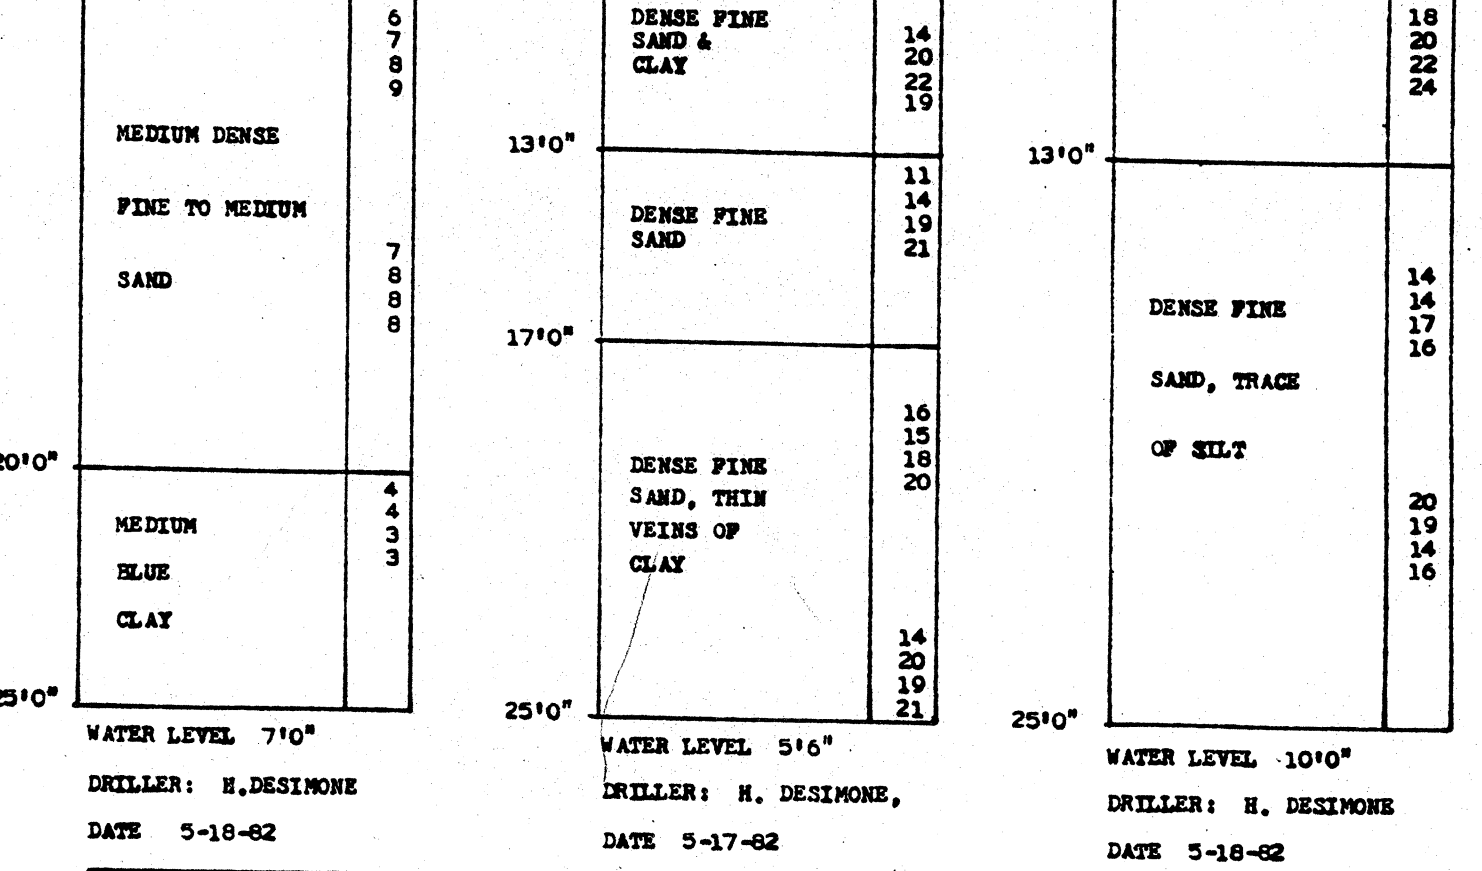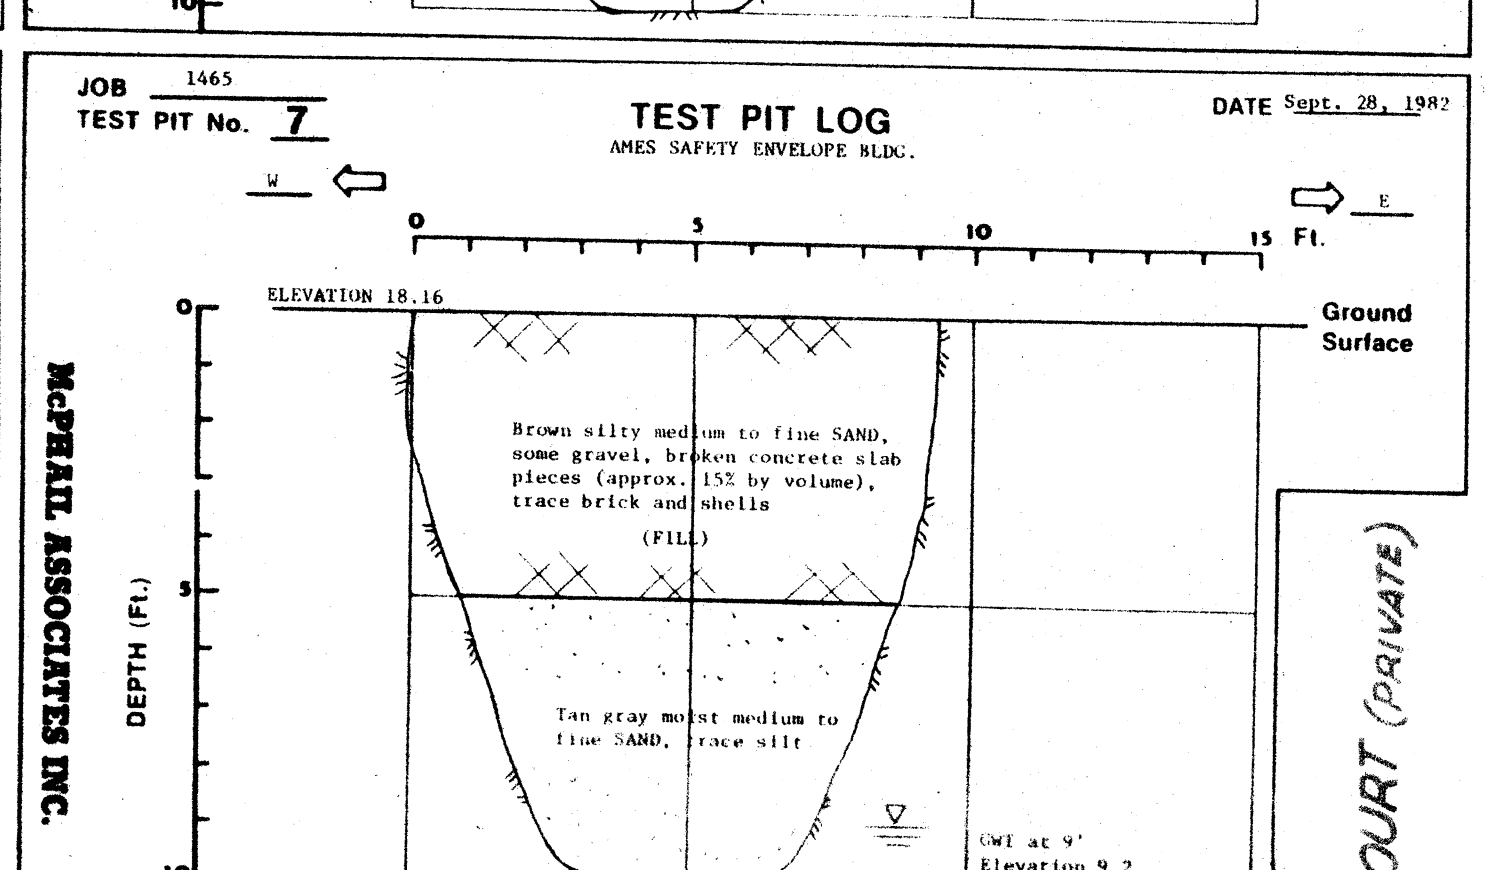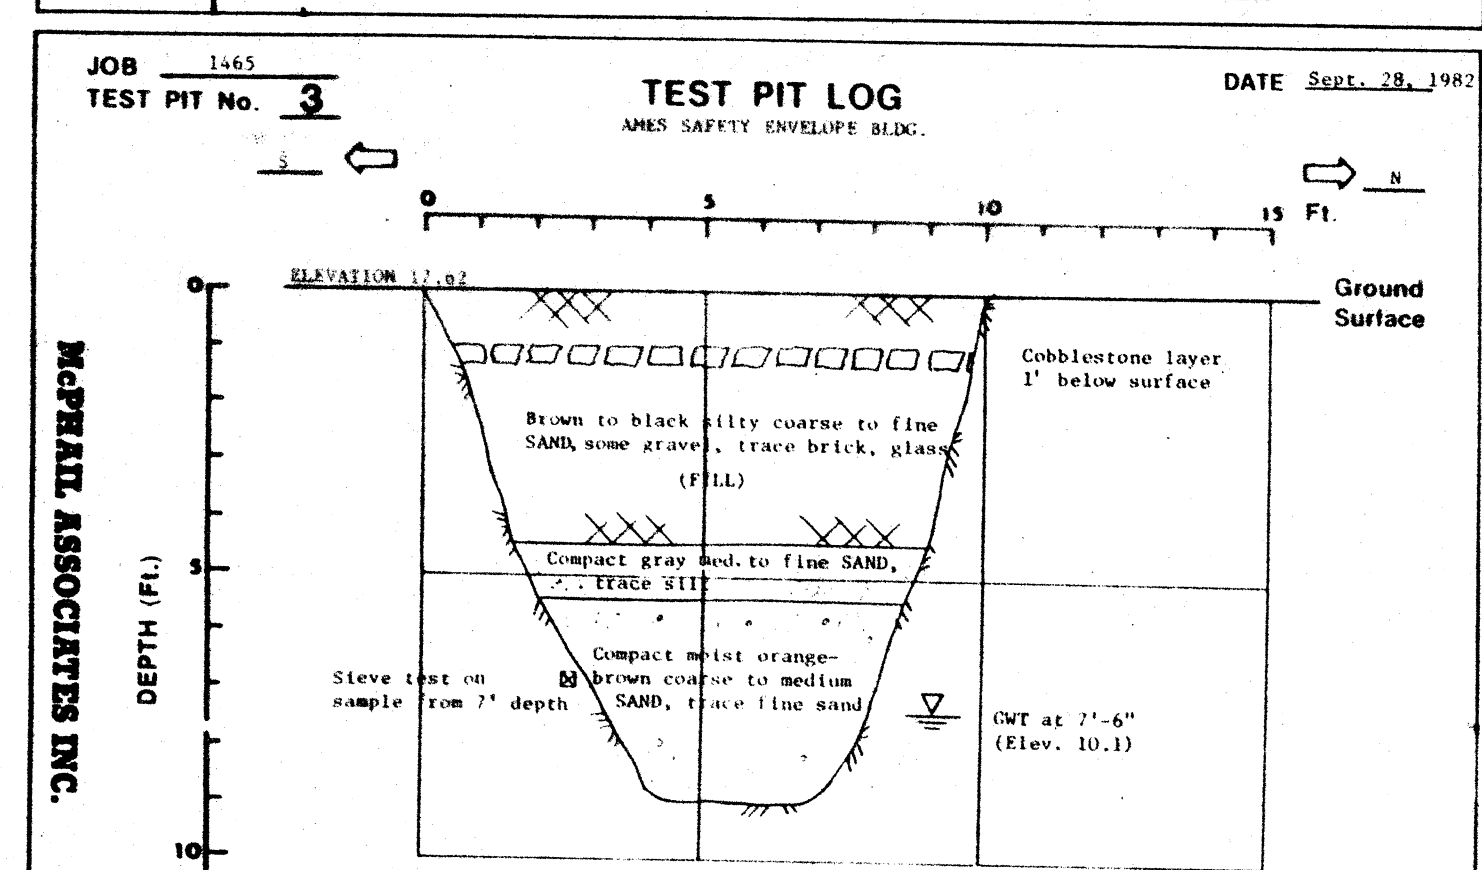



1. BENCHMARKS: Existing inverts combined sanitary sewer manholes in Tyler Street Inv. 11.65 and Inv. 12.12. See Plan for locations.
2. This is a COMPILED PLAN of topographic and boundary information supplied by the owner. Topographic and property line data taken from plan entitled "Topographic Plan Tyler and Dane Street, Somerville, MA; Scale 1"=20'; May 1, 1981 Fred W. Gould, Surveyor." Additional property data taken from plan entitled "City of Somerville, Abandonment of a Portion of Reverend Nazareno Properzi Way Formerly Vine Street, February 10, 1982, scale as noted" and Plan entitled Plan of Land in Somerville, MA, March 29, 1982, Scale 1"=40'." Both prepared by Somerville Engineering, Inc., 265 Medford Street, Somerville, MA 02143.
3. Contractor is responsible for the protection of adjacent property. Provide adequate shoring and/or bracing to ensure no settlement or damage to abutting utilities, structures or property.
4. All work done in public ways shall conform to City of Somerville Engineering Department Requirements. Contact City Engineer prior to commencing work in public ways.
5. Contractor shall obtain all required permits at no additional expense to the owner.
6. All new water lines shall have a minimum 5 feet cover.
7. Contractor shall notify City of Somerville Engineering Department and utility companies prior to removal of utilities in Properzi Way as shown.
8. Existing Granite Curbing removed at trucking driveway shall be relocated to close existing curb cuts as shown. Provide new curb returns. Dispose of extra granite curbing as directed by City of Somerville Engineering Department.

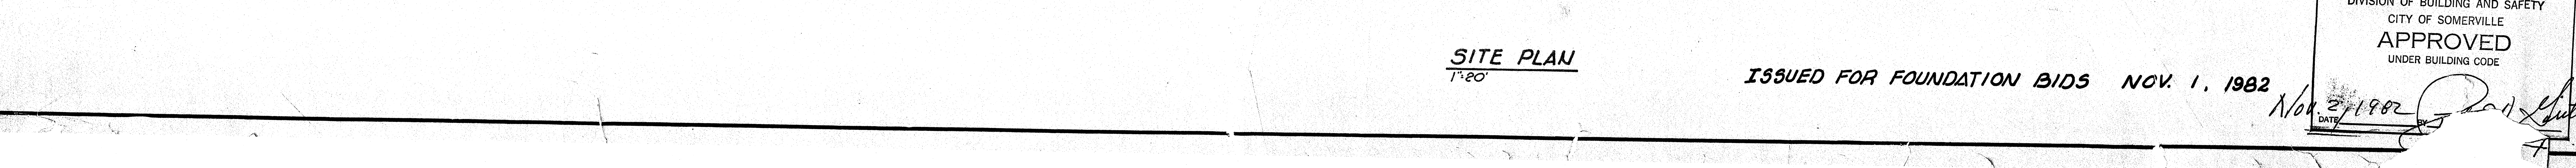

SCALE/NOTED	DATE 11.1.82	DR BY S.J.R.	CK BY R.M.F.	JOB NO. 820308
-------------	--------------	--------------	--------------	----------------

L1


Lot 1	1405	S.F.
Lot 2	223	S.F.
Lot 3	3662	S.F.
Lot 4	2467	S.F.
Lot 5	1174	S.F.
Total	8931	S.F.

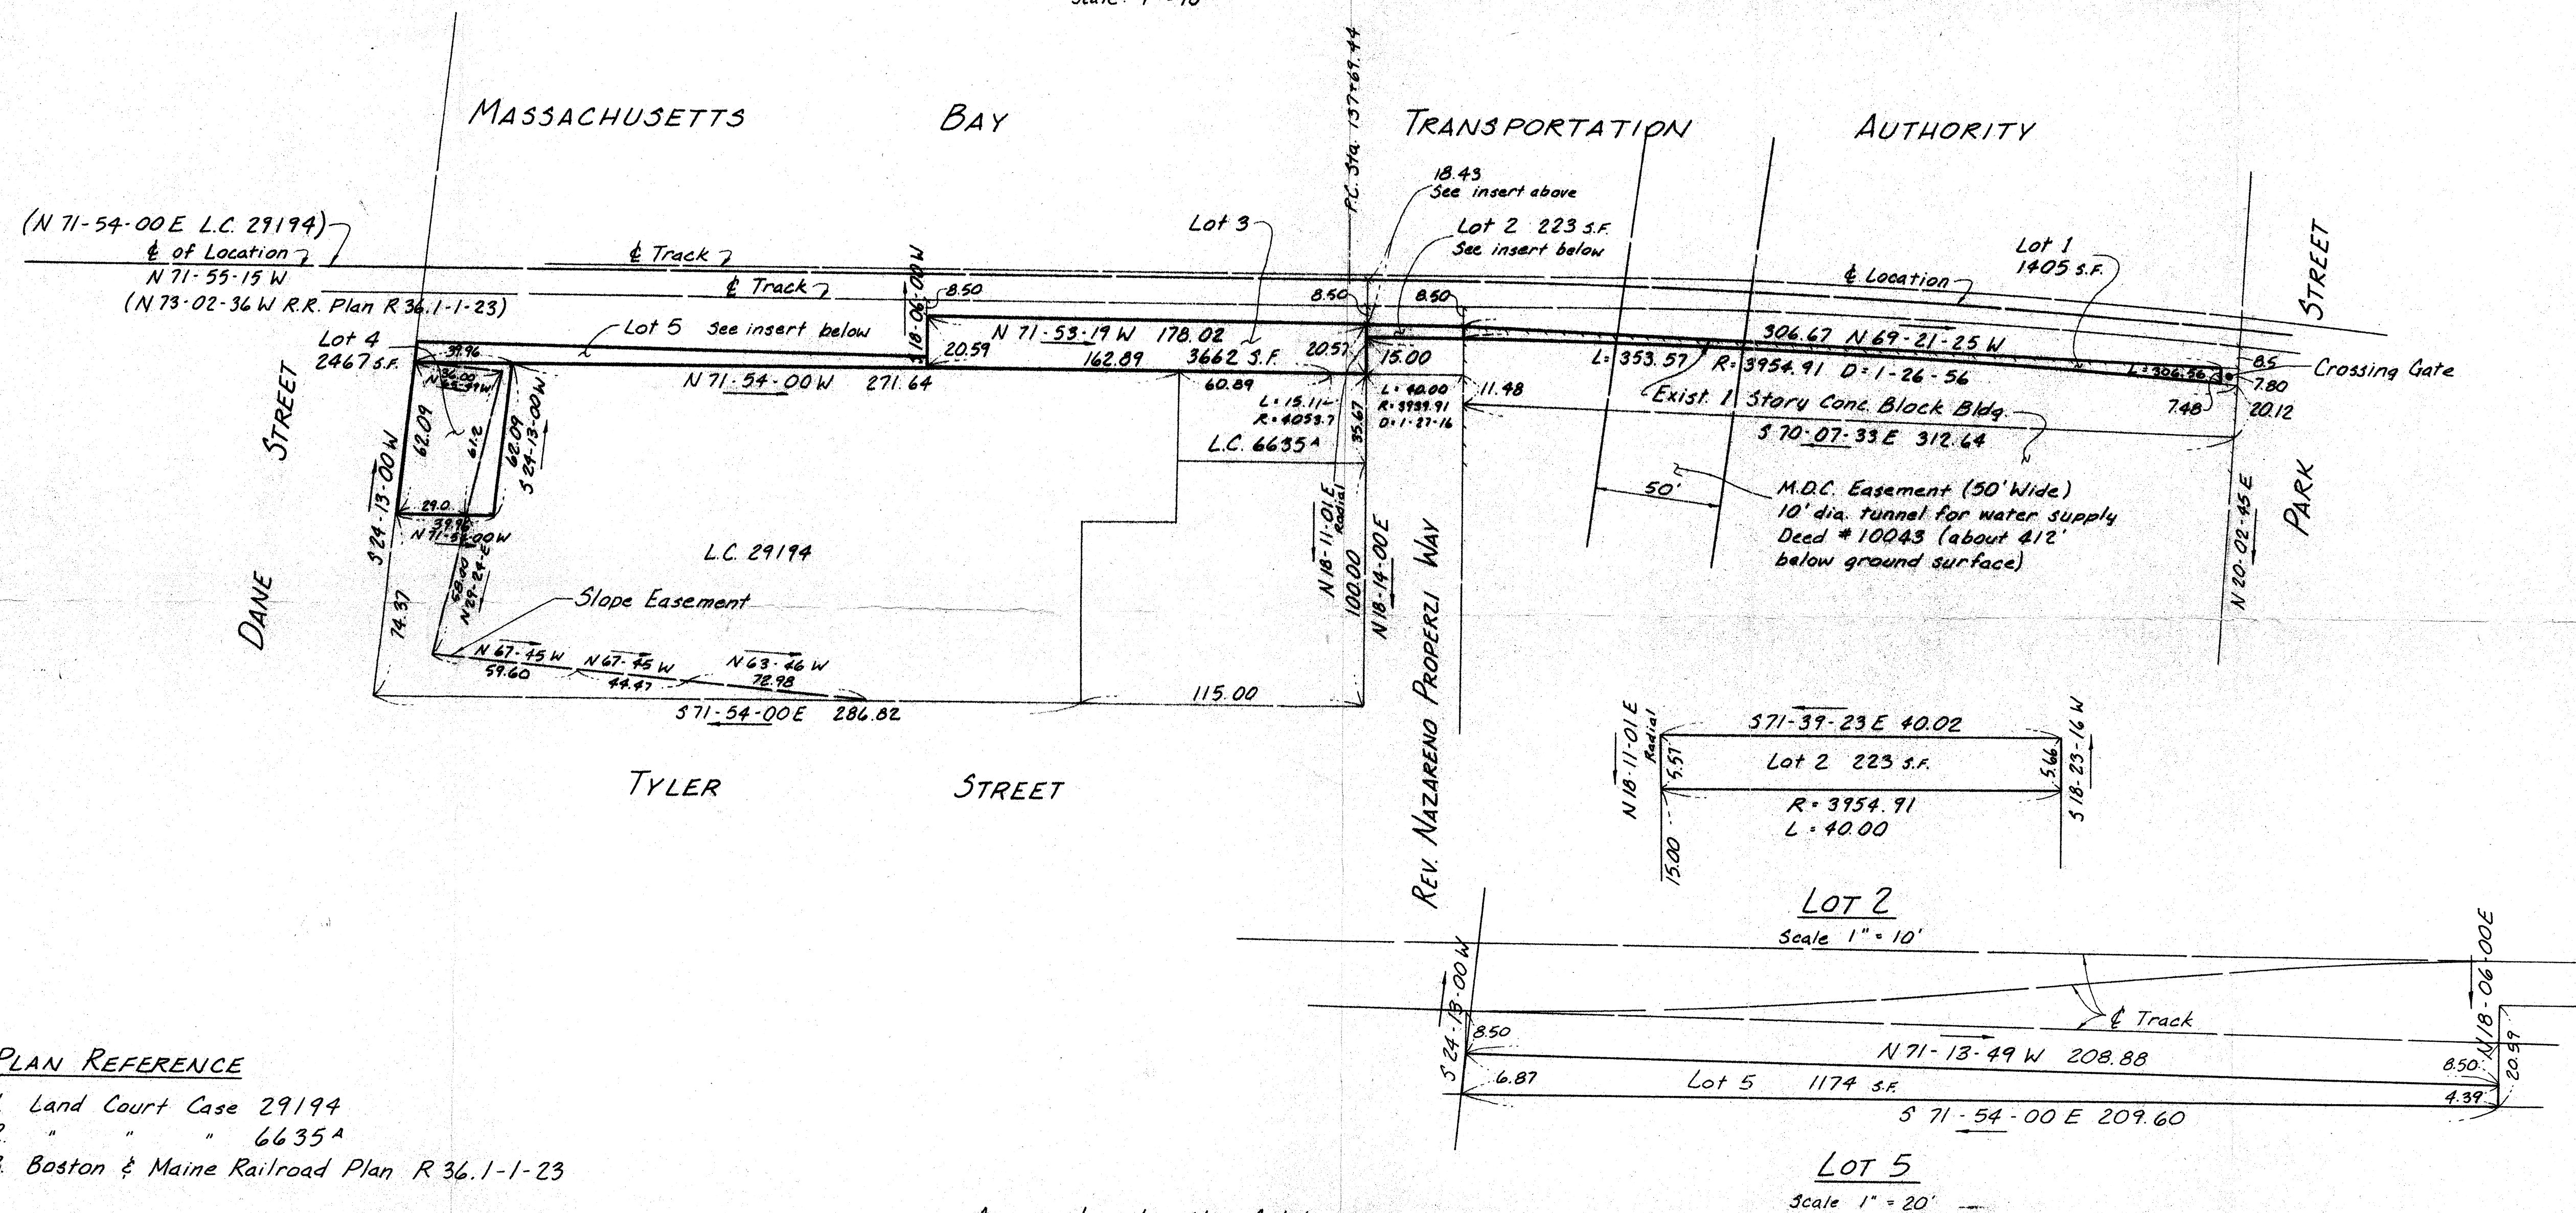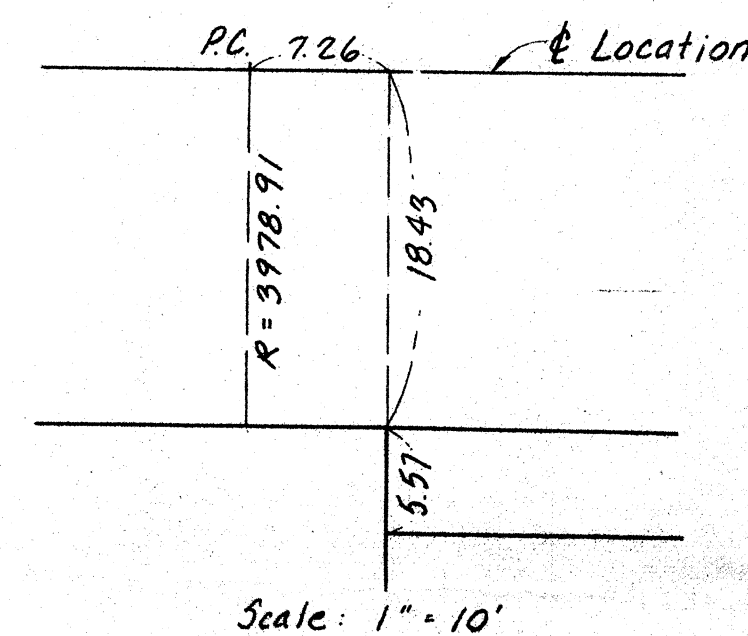

1. Land Court Case 29194
2. " " " 6635^A
3. Boston & Maine Railroad Plan R 36.1-1-23

Approval under the Subdivision
Control Law not Required
Somerville Planning Commission

Date _____

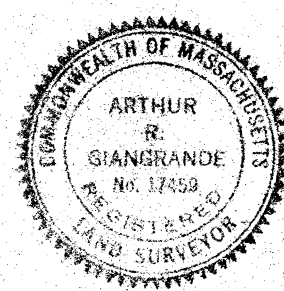

I certify that this plan was prepared in conformity with the rules and regulations of the Registers of Deeds.

Arthur B. Giangrande.

PLAN OF LAND
IN
SOMERVILLE, MASS.

MARCH 29, 1982 SCALE: 1" = 40'

SOMERVILLE ENGINEERING, INC.
265 MEDFORD STREET
SOMERVILLE, MASS. 02143

Scale : 1" = 40'



DANE ST.

TYLER ST.



1 DEMO PLAN
scale: 1/8" = 1'-0"


Robert Luchetti Associates, Inc.
17 Properzl Way
Somerville, MA 02143
617 623 7611
617 623 8441 FAX

**MIT Museum
Warehouse
Tenant Fit Out**
8 Tyler St.
Somerville, MA 02143

- DRAWING LIST**
D1.0 DEMO PLAN
A1.0 FLOOR PLAN
A1.1 ENLARGED PLAN &
ELEVATIONS
A1.2 PARTIAL REFLECTED CEILING
PLAN
A1.3 DETAILS AND SCHEDULES
BUILDING CODE ANALYSIS (UNDER
SEPARATE COVER)

**BUILDING PERMIT SET
DEMO PLAN**

Date: 09.27.11 Scale: As Noted
Drawn By: RB
Revised:

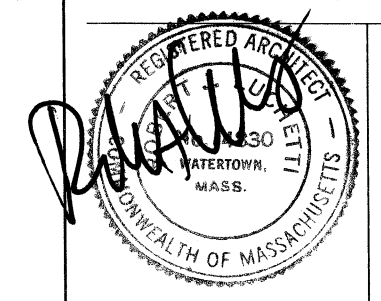

D1.0

MIT Museum
Warehouse
Tenant Fit Out

8 Tyler St.
Somerville, MA 02143



Legend

NEW WALL

2 KEY PLAN
scale: NOT TO SCALE

Notes


1. NEW FIRE ALARM WORK: THIS WORK IS TO BE COMPLETED ON A DESIGN - BUILD BASIS BY A CONTRACTOR LICENSED IN MASSACHUSETTS. CONTRACTOR TO PROVIDE AND INSTALL FIRE ALARM PULLS AND HORN STROBES, TIE INTO AND COORDINATE WITH THE EXISTING BUILDING FIRE ALARM SYSTEM AND TO COORDINATE THIS WORK WITH THE LANDLORDS REPRESENTATIVE AND THE CITY OF SOMERVILLE FIRE DEPARTMENT AS REQU'D BY CODE.
2. CONTRACTOR TO PROVIDE AND INSTALL EMERGENCY EXIT SIGNS AND EMERGENCY LIGHTING AS REQU'D BY CODE FOR THE TENANT'S OCCUPANCY.
3. INSTALL ONE HOUR FIRE DAMPERS WHERE RATED PARTITIONS INTERSECT HVAC DUCTWORK.
4. ALL DOORS MUST REMAIN UNLOCKED ALONG PATH OF EGRESS TRAVEL.
5. FIRE SUPPRESSION SPRINKLERS. THE EXISTING WAREHOUSE SPACE IS CURRENTLY PROVIDED WITH A COMPLETE FIRE SPRINKLER SYSTEM. CONTRACTOR TO PROVIDE AND INSTALL NEW SPRINKLER HEADS AS REQU'D IN THE TOILET ROOMS & NEW CORRIDOR. THE REQU'D NEW SPRINKLER WORK IS TO BE COMPLETED ON A DESIGN - BUILD BASIS BY A CONTRACTOR LICENSED IN MASSACHUSETTS. THE CONTRACTOR IS TO RETAIN A REGISTERED ENGINEER QUALIFIED BY THE STATE OF MASSACHUSETTS TO DETERMINE THE QUANTITY AND LAYOUT OF THE REQU'D NEW SPRINKLER HEADS AND TO PROVIDE AND INSTALL THESE AND TO COORDINATE THIS WORK WITH THE LANDLORDS REPRESENTATIVE AND THE CITY OF SOMERVILLE FIRE DEPARTMENT AS REQU'D BY CODE.
6. NEW HVAC WORK: CONTRACTOR TO RELOCATE, INSTALL AND COMMISSION TWO EXISTING AIR CONDITIONING UNITS AND TO COORDINATE THE MODIFICATIONS OF THE EXISTING BUILDING HEATING SYSTEM IN THE NEW WORK. THIS WORK IS TO BE COMPLETED ON A DESIGN-BUILD BASIS BY A CONTRACTOR LICENSED IN MASSACHUSETTS TO COMPLETE THIS WORK.
8. NEW PLUMBING WORK: THIS WORK IS TO BE COMPLETED ON A DESIGN - BUILD BASIS BY A CONTROR LICENSED IN MASSACHUSETTS.
9. CONTRACTOR TO PROVIDE AND INSTALL NEW VCT IN NEW RESTROOMS.

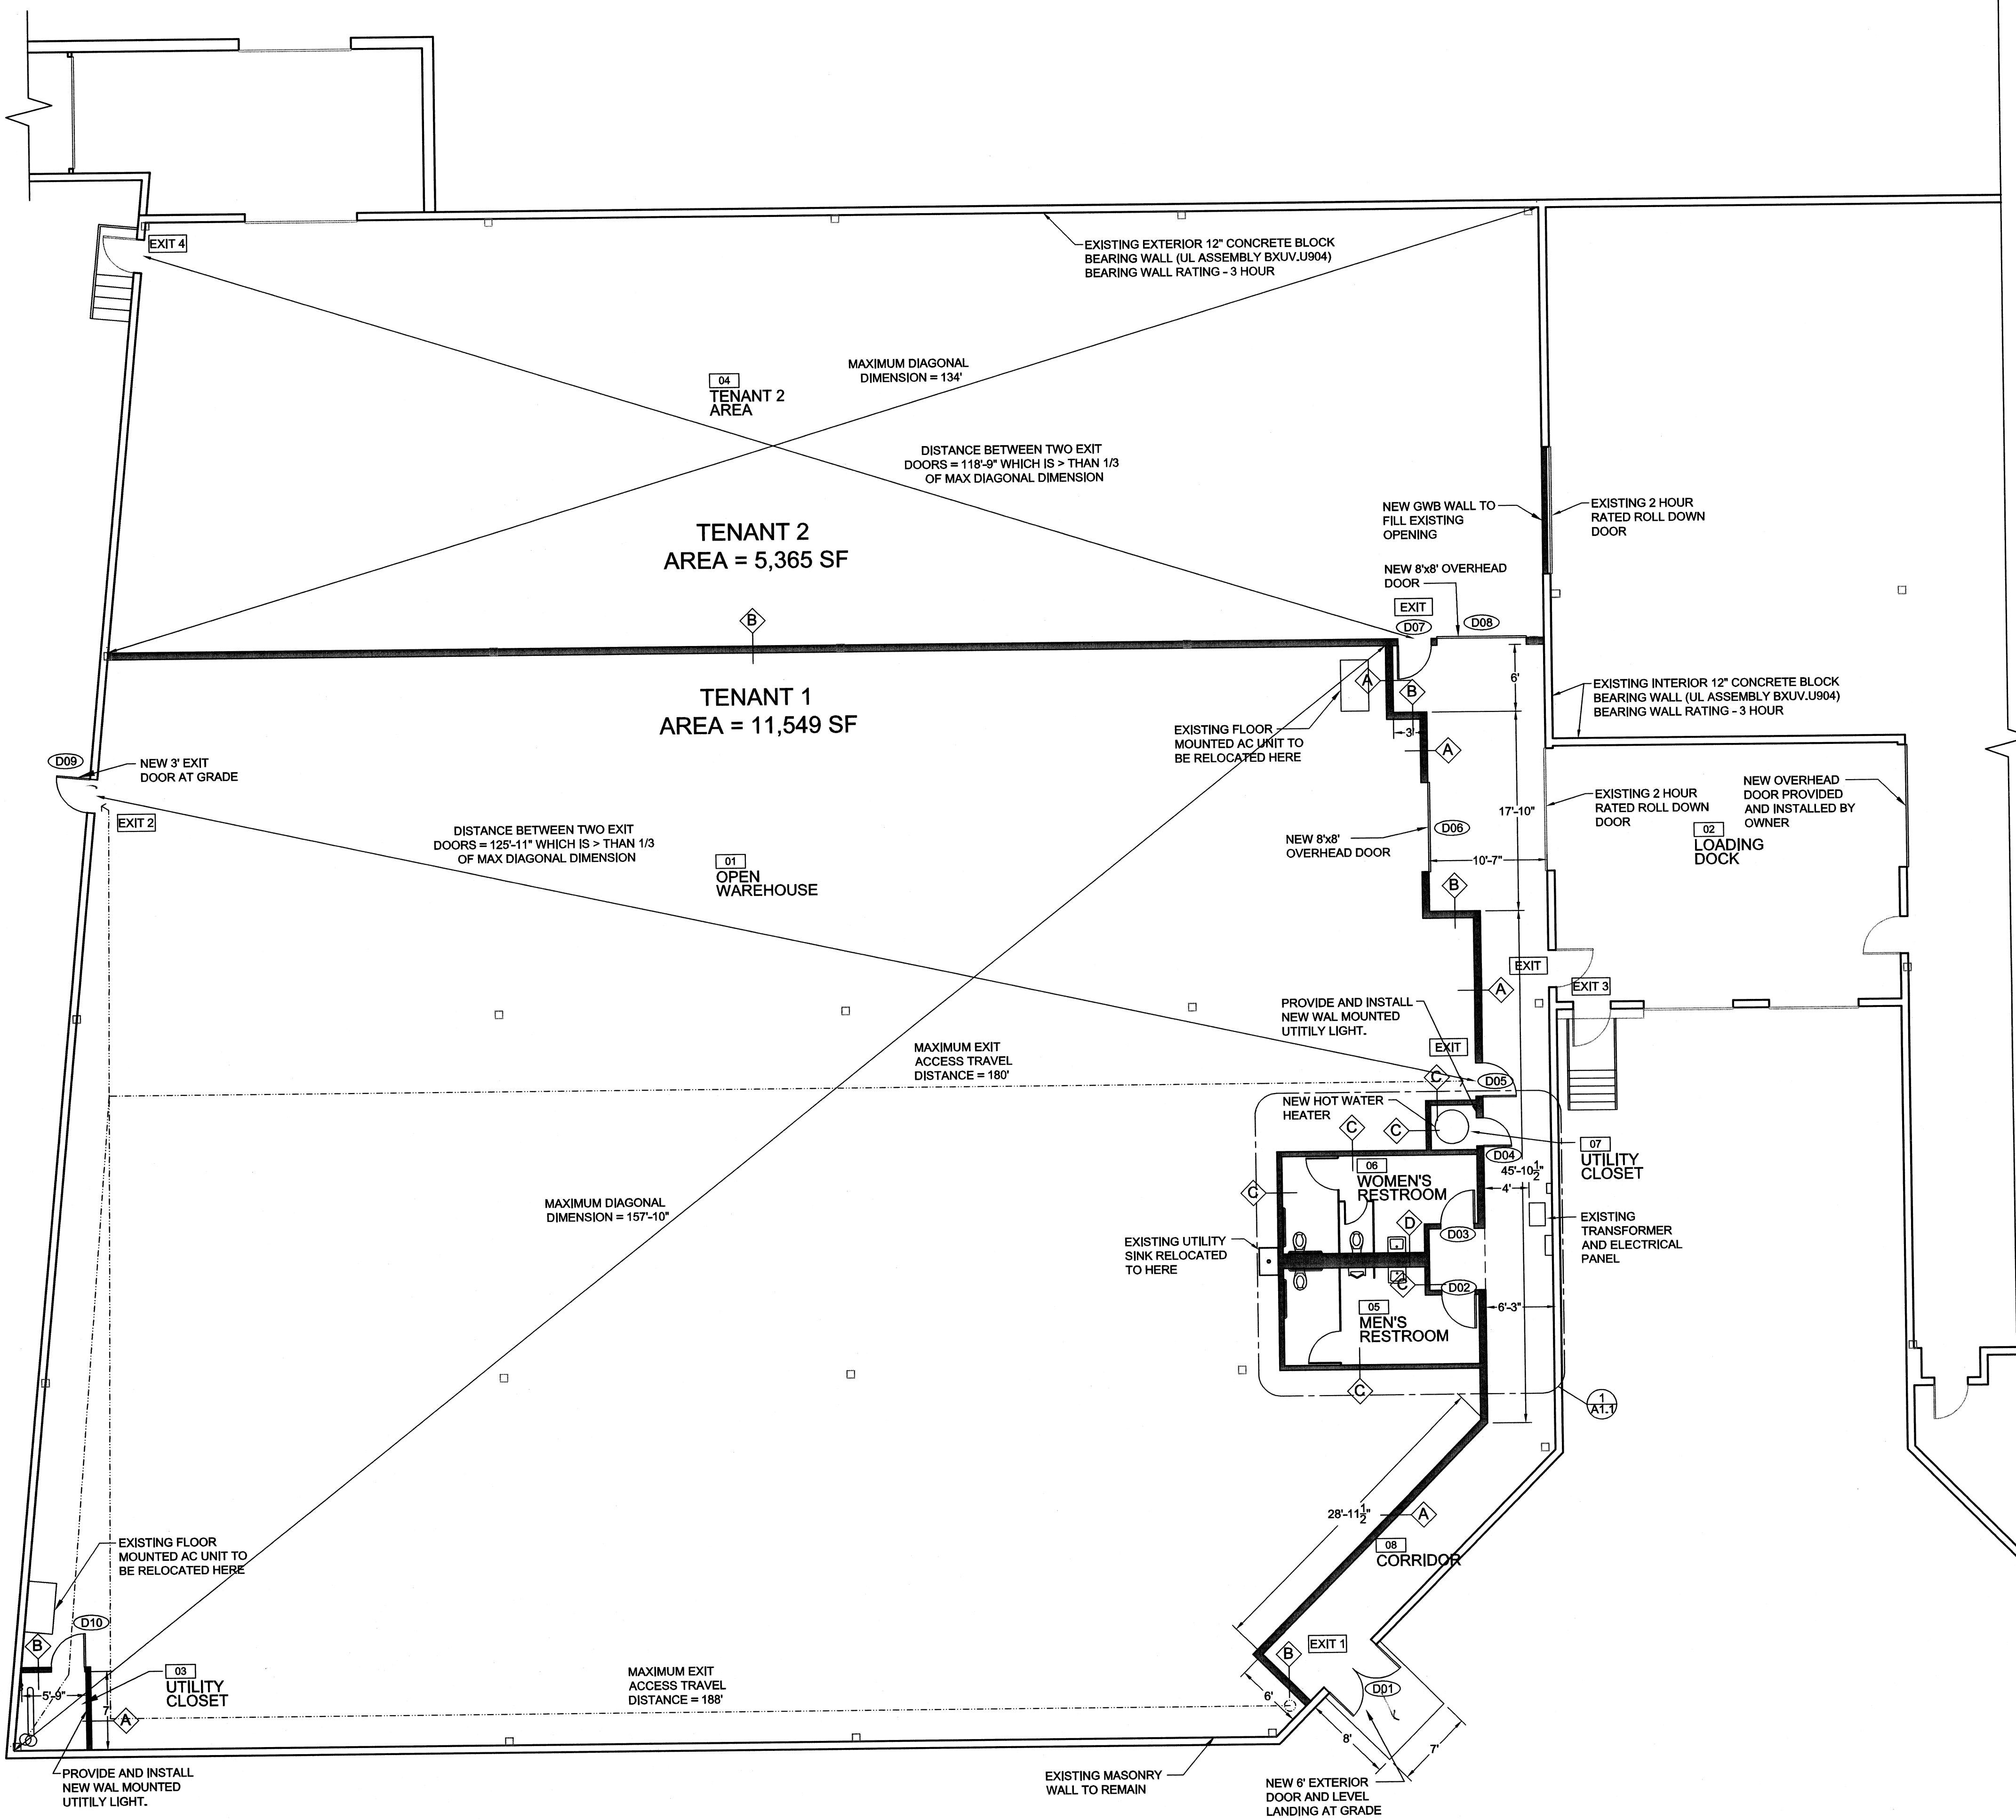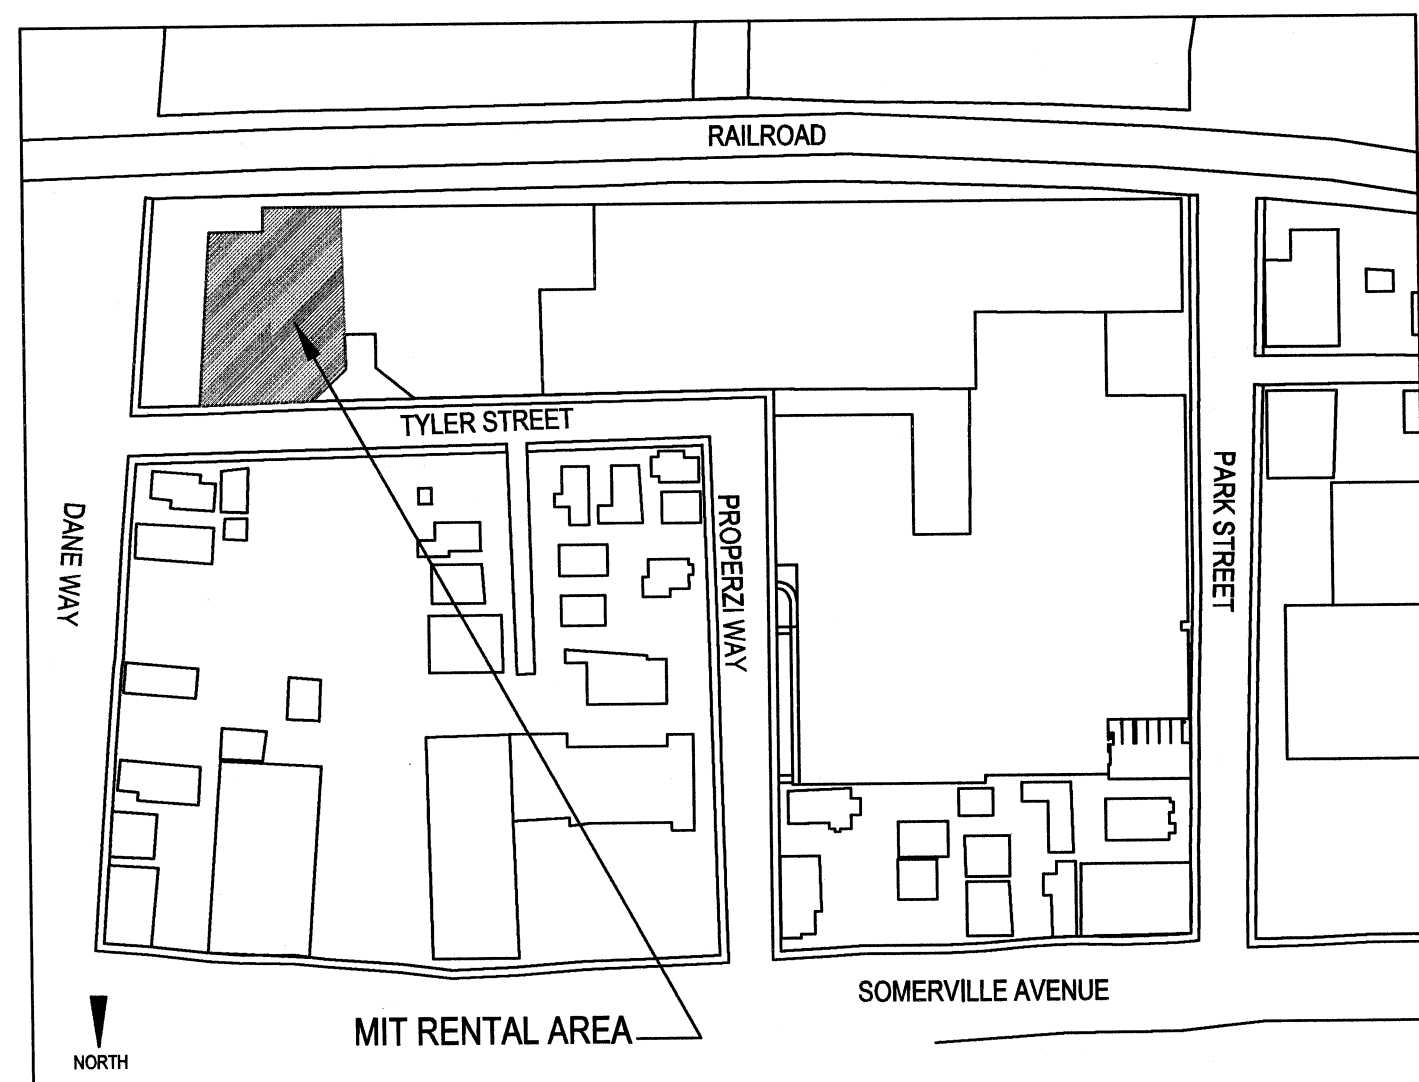

1 PLAN AT 8 TYLER ST
scale: 1/8" = 1'-0"

PERMIT SET
PLAN

Date: 09.27.11 Scale: As Noted
Drawn By: RB
Reviewed:

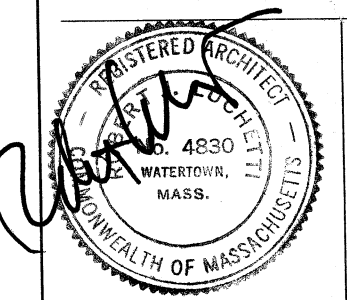


A1.0


MIT Museum
Warehouse
Tenant Fit Out
8 Tyler St.
Somerville, MA 02143

Legend


Notes

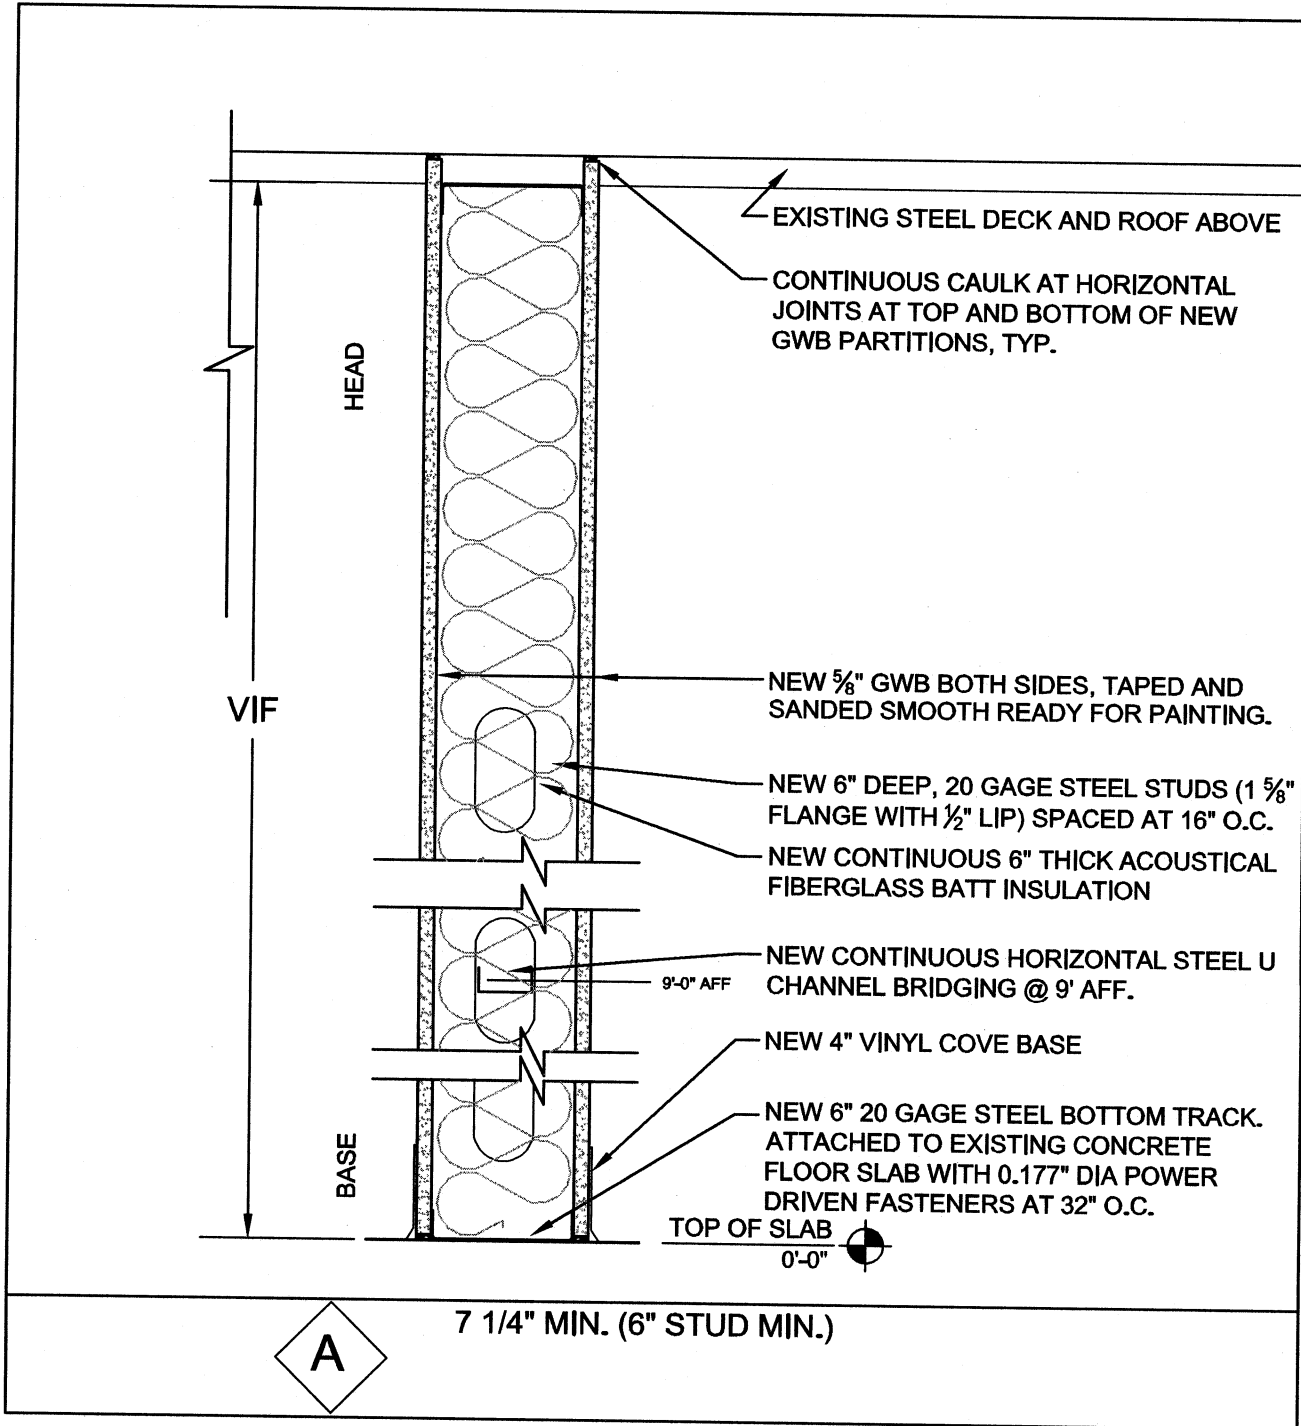


1 WALL TYPE A SECTION DETAIL
scale: 1 1/2" = 1'-0"

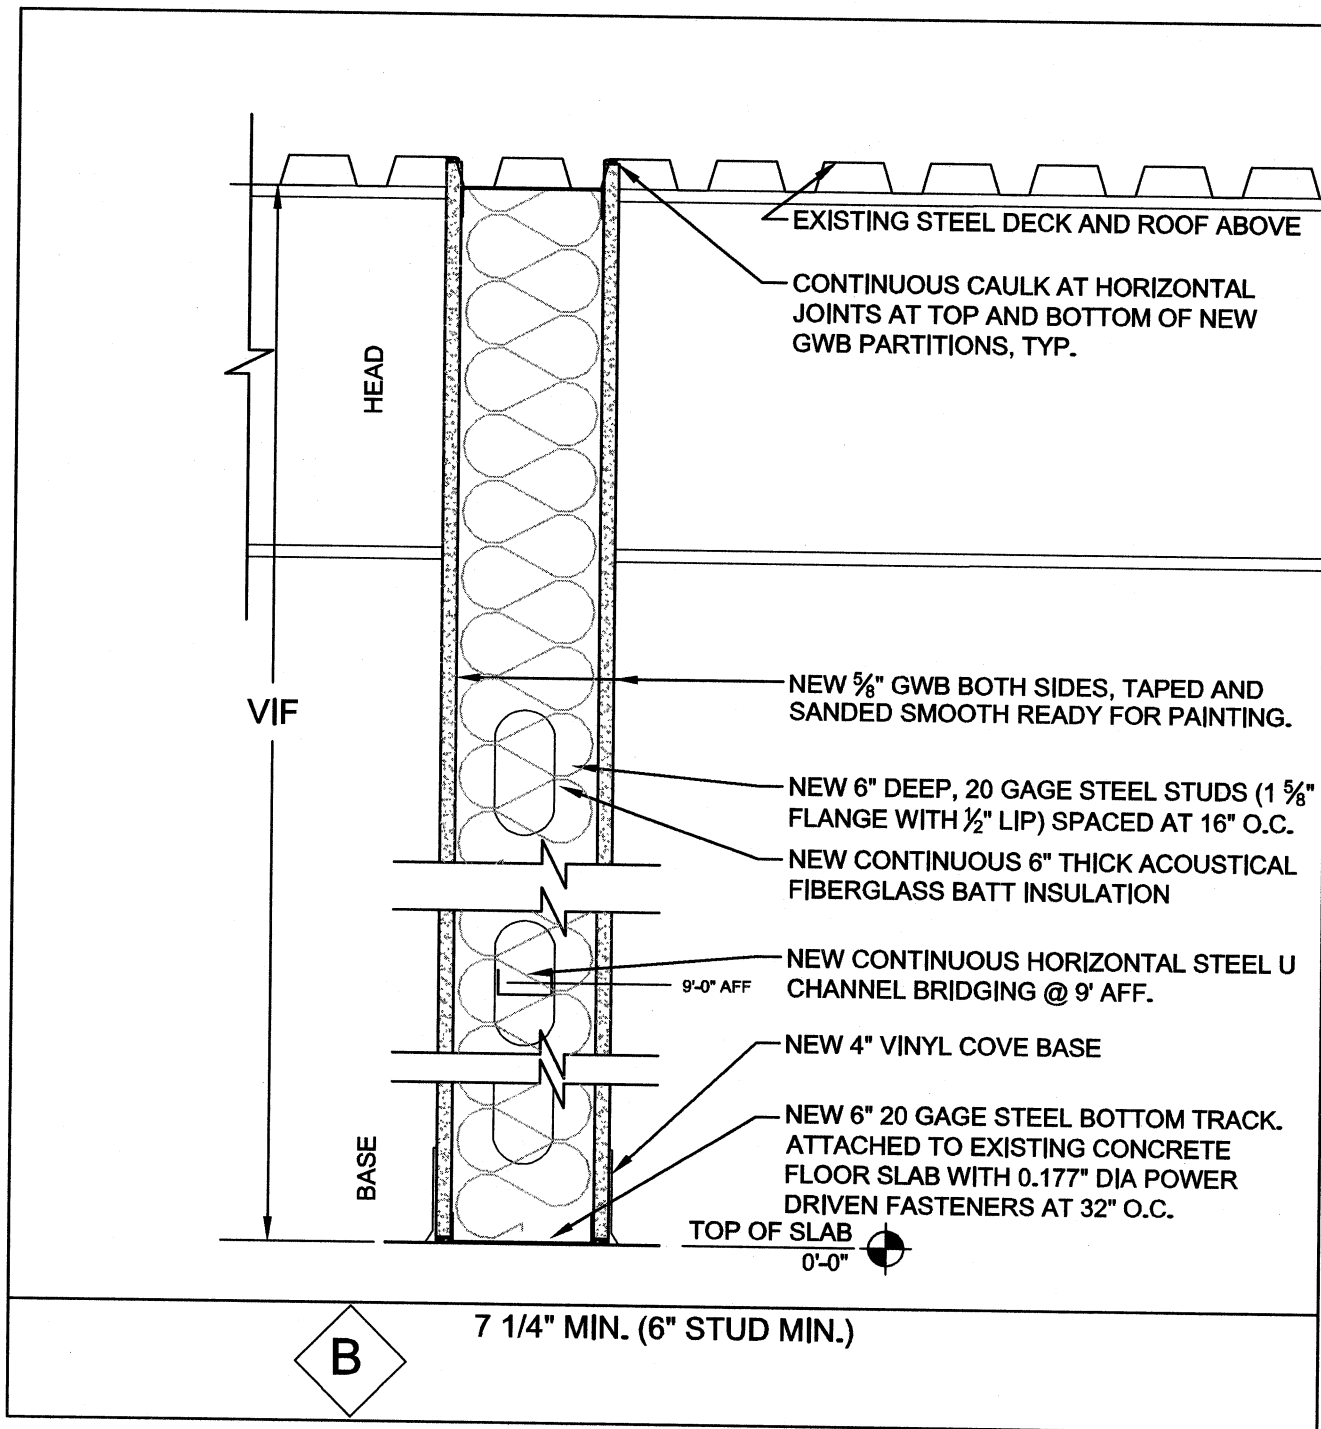

2 WALL TYPE B SECTION DETAIL
scale: 1 1/2" = 1'-0"

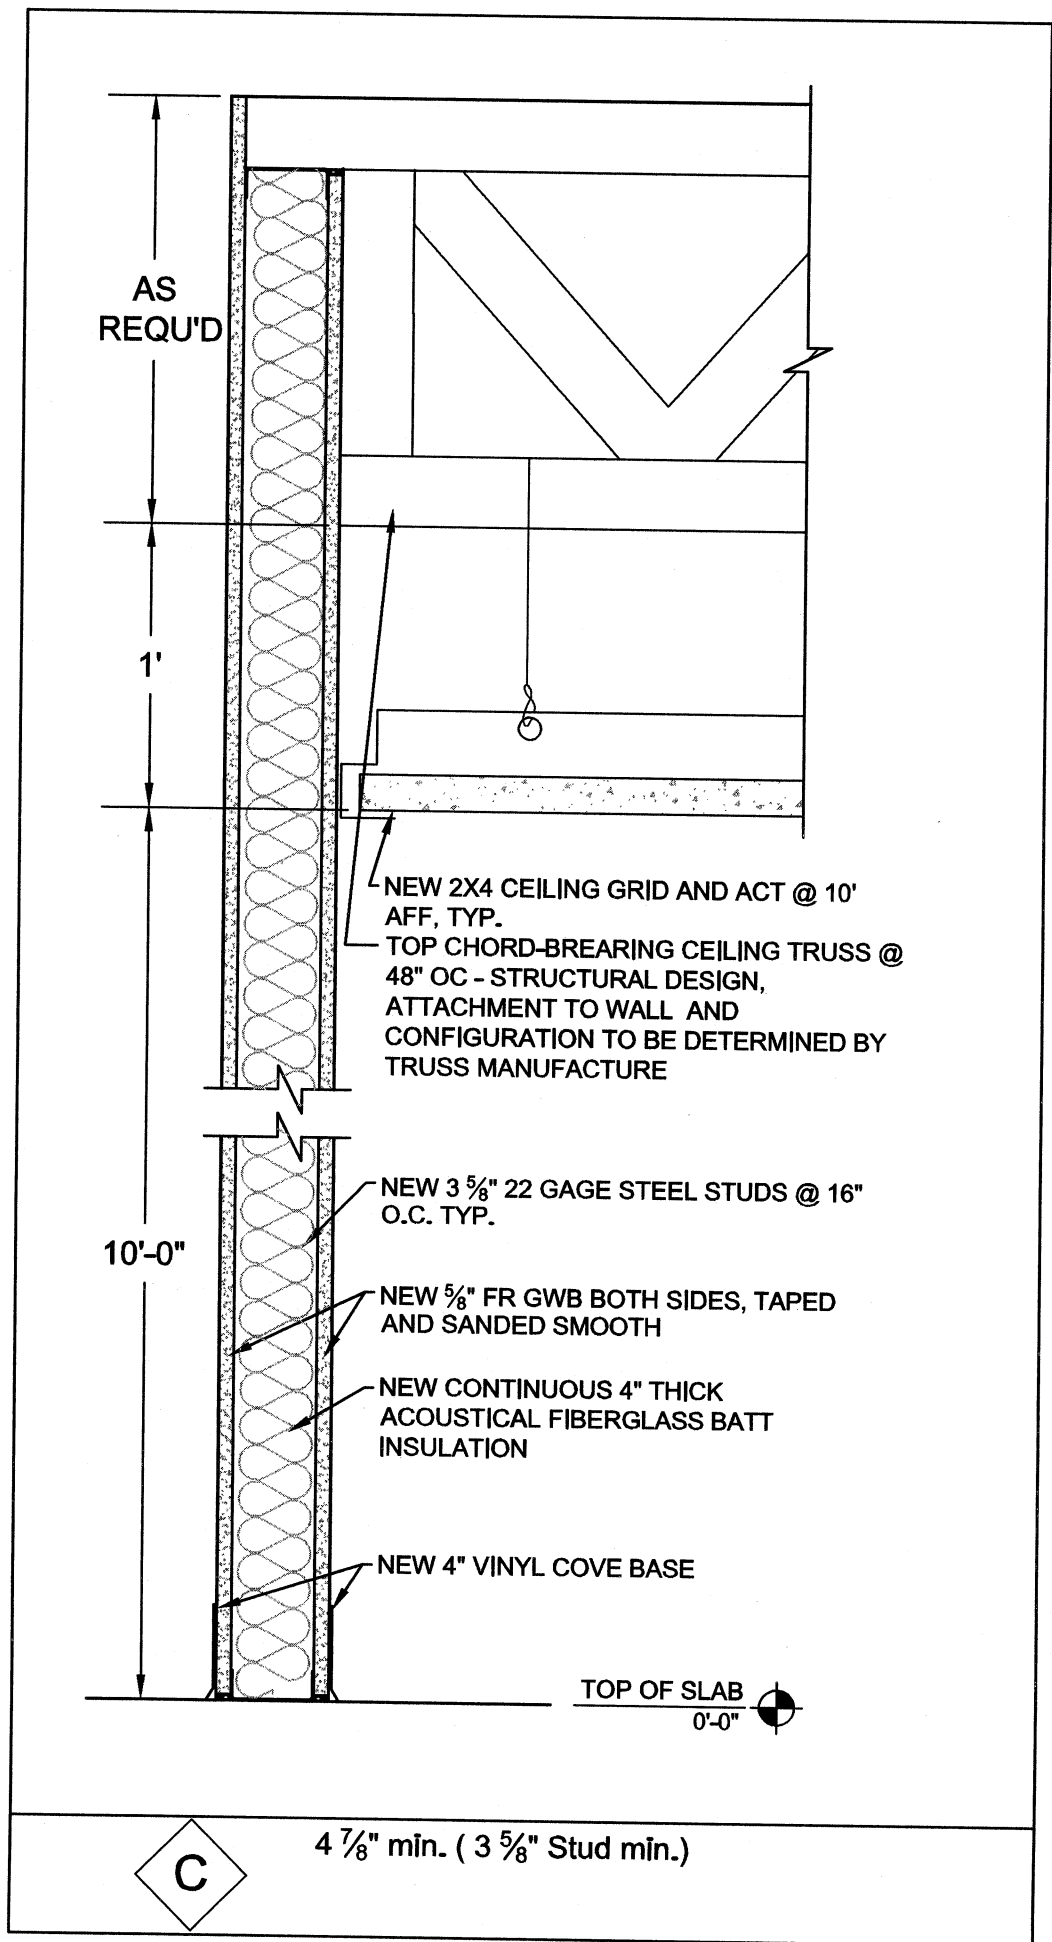

3 WALL TYPE C SECTION DETAIL
scale: 1 1/2" = 1'-0"

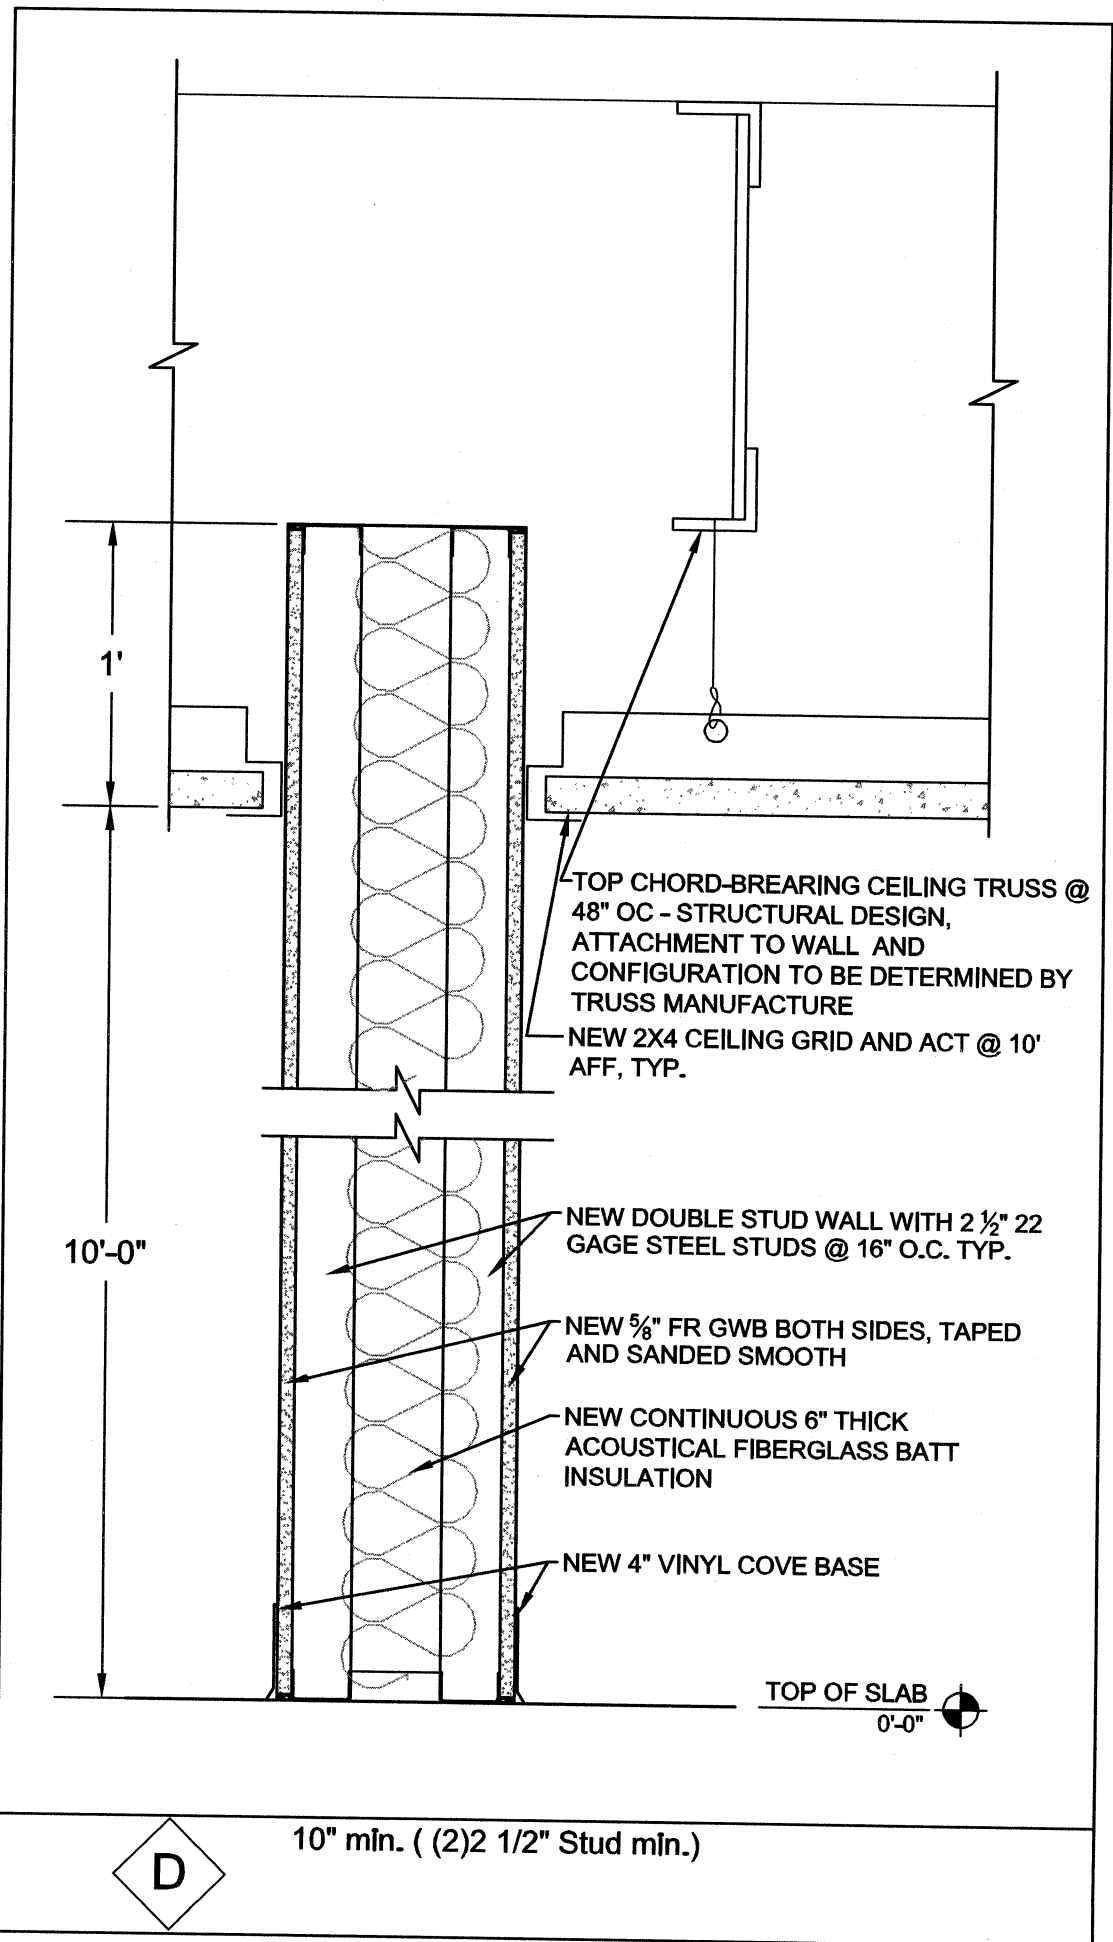

4 WALL TYPE D SECTION DETAIL
scale: 1 1/2" = 1'-0"

DOOR NO.	LOCATION		DOOR TYPE	SIZE		FRAME	DOOR	DOOR & FRAME FIRE RATING	FINISH	HARDWARE									
	ROOM NO.	ROOM NAME		WIDTH	HEIGHT					Hinges - 1.5 pair/door TYP	Lockset	Lockset Finish	Handle	Handle Finish	Trim	Closer	Closer Finish		
D01	08	Corridor	Double Hinged	6'-0" (pair of 3'-0" doors)	7'-0"	Hollow Metal	Exterior Hollow Metal	1 hour	Painted	Ives 5-BB-1-HW-3.5x3.5-630-NRP	Von Durpin 22-F Rim Fire Exit Device	USSP28 BE	22K-F w 210K	US32D	Knob and Keyed Lock @ Exterior	LCN 4030	USS28P		
D02	05	Men's Restroom	Single Hinged	3'-0"	7'-0"	Hollow Metal	Hollow Metal w/ 24"x24" louvers at bottom of	NA	Painted	Ives 5BB-1-HW-3.5x3.5-630-NRP	None	US32D	Pull @ Exterior - Ives 8103EZ	YS32D	Push Plate at Interior Ives 8200 6" x 16"	LCN 4010	USS28P		
D03	06	Women's Restroom	Single Hinged	3'-0"	7'-0"	Hollow Metal	Hollow Metal w/ 24"x24" louvers at	NA	Painted	Ives 5BB-1-HW-3.5x3.5-630-NRP	None	US32D	Pull @ Exterior - Ives 8103EZ	YS32D	Push Plate at Interior Ives 8200 6" x 16"	LCN 4010	USS28P		
D04	087	Utility Closet	Single Hinged	2'-6"	7'-0"	Hollow Metal	Interior Hollow Metal	NA	Painted	Ives 5-PB-1-HW-3.5x3.5-630-NRP	tbd								
D05	01	Open Warehouse	Single Hinged	3'-0"	7'-0"	Hollow Metal	Interior Hollow Metal	1 hour	Painted	Ives 5-BB-1-HW-3.5x3.5-630-NRP	Von Durpin 22-F Rim Fire Exit Device	USSP28 BE	22K-F w 210K	US32D	Knob and Keyed Lock @ comidor side	LCN 4030	USS28P		
D06	01	Open Warehouse	Overhead Door Company Rolling Sheet Door	8'-0"	8'-0"	As Required	770SS	NA	Factory Primed Painted										
D07	04	Tenant 2 Area	Single Hinged	3'-0"	7'-0"	Hollow Metal	Interior Hollow Metal	1 hour	Painted	Ives 5-BB-1-HW-3.5x3.5-630-NRP	Von Durpin 22-F Rim Fire Exit Device	USSP28 BE	22K-F w 210K	US32D	Knob and Keyed Lock @ comidor side	LCN 4030	USS28P		
D08	04	Tenant 2 Area	Overhead Door Company Rolling Sheet Door	8'-0"	8'-0"	As Required	770SS	NA	Factory Primed Painted										
D09	01	Open Warehouse	Single Hinged	3'-0"	7'-0"	Hollow Metal	Exterior Hollow Metal	1 hour	Painted	Ives 5-BB-1-HW-3.5x3.5-630-NRP	Von Durpin 22-F Rim Fire Exit Device	USSP28 BE	22K-F w 210K	US32D	Knob and Keyed Lock @ Exterior	LCN 4030	USS28P		
D10	03	Utility Closet	Single Hinged	3'-0"	7'-0"	Hollow Metal	Interior Hollow Metal	NA	Painted	Ives 5-PB-1-HW-3.5x3.5-630-NRP	tbd								


5 DOOR SCHEDULE
scale: NOT TO SCALE

Room Name	Room Number	Floor Finish	Wall Base				Wall Finish				Ceiling Finish
			N	S	E	W	N	S	E	W	
Open Warehouse	01	Existing	4" vinyl cove base	Existing	4" vinyl cove base	Existing	GWB smooth ready for painting	Existing	GWB smooth ready for painting	Existing	None
Loading Dock	02	Existing	Existing	Existing	Existing	Existing	Existing	Existing	Existing	Existing	Existing
Utility Closet	03	Existing	4" vinyl cove base	Existing	4" vinyl cove base	Existing	GWB smooth ready for painting	Existing	GWB smooth ready for painting	Existing	Existing
Tenant 2 Area	04	Existing	Existing	4" vinyl cove base	Existing	Existing	Existing	GWB smooth ready for painting	Existing	Existing	Existing
Men's Restroom	05	Existing	4" vinyl cove base	4" vinyl cove base	4" vinyl cove base	4" vinyl cove base	FRP Panels & Trim	FRP Panels & Trim	FRP Panels & Trim	FRP Panels & Trim	Suspended 2x4 ACT
Women's Restroom	06	Existing	4" vinyl cove base	4" vinyl cove base	4" vinyl cove base	4" vinyl cove base	FRP Panels & Trim	FRP Panels & Trim	FRP Panels & Trim	FRP Panels & Trim	Suspended 2x4 ACT
Utility Closet	07	Existing	4" vinyl cove base	4" vinyl cove base	4" vinyl cove base	4" vinyl cove base	GWB smooth ready for painting	GWB smooth ready for painting	GWB smooth ready for painting	GWB smooth ready for painting	GWB 8'-0" AFF
Corridor	08	Existing	4" vinyl cove base	4" vinyl cove base	Existing	4" vinyl cove base	GWB smooth ready for painting	GWB smooth ready for painting	Existing	GWB smooth ready for painting	Existing

6 ROOM FINISH SCHEDULE
scale: NOT TO SCALE

PERMIT SET
DETAILS & SCHEDULES

Date: 09.27.11 Scale: As Noted
Drawn By: RB
Reviewed:

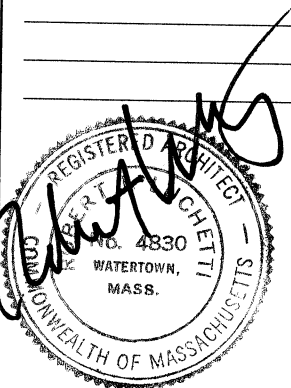

A1.3