



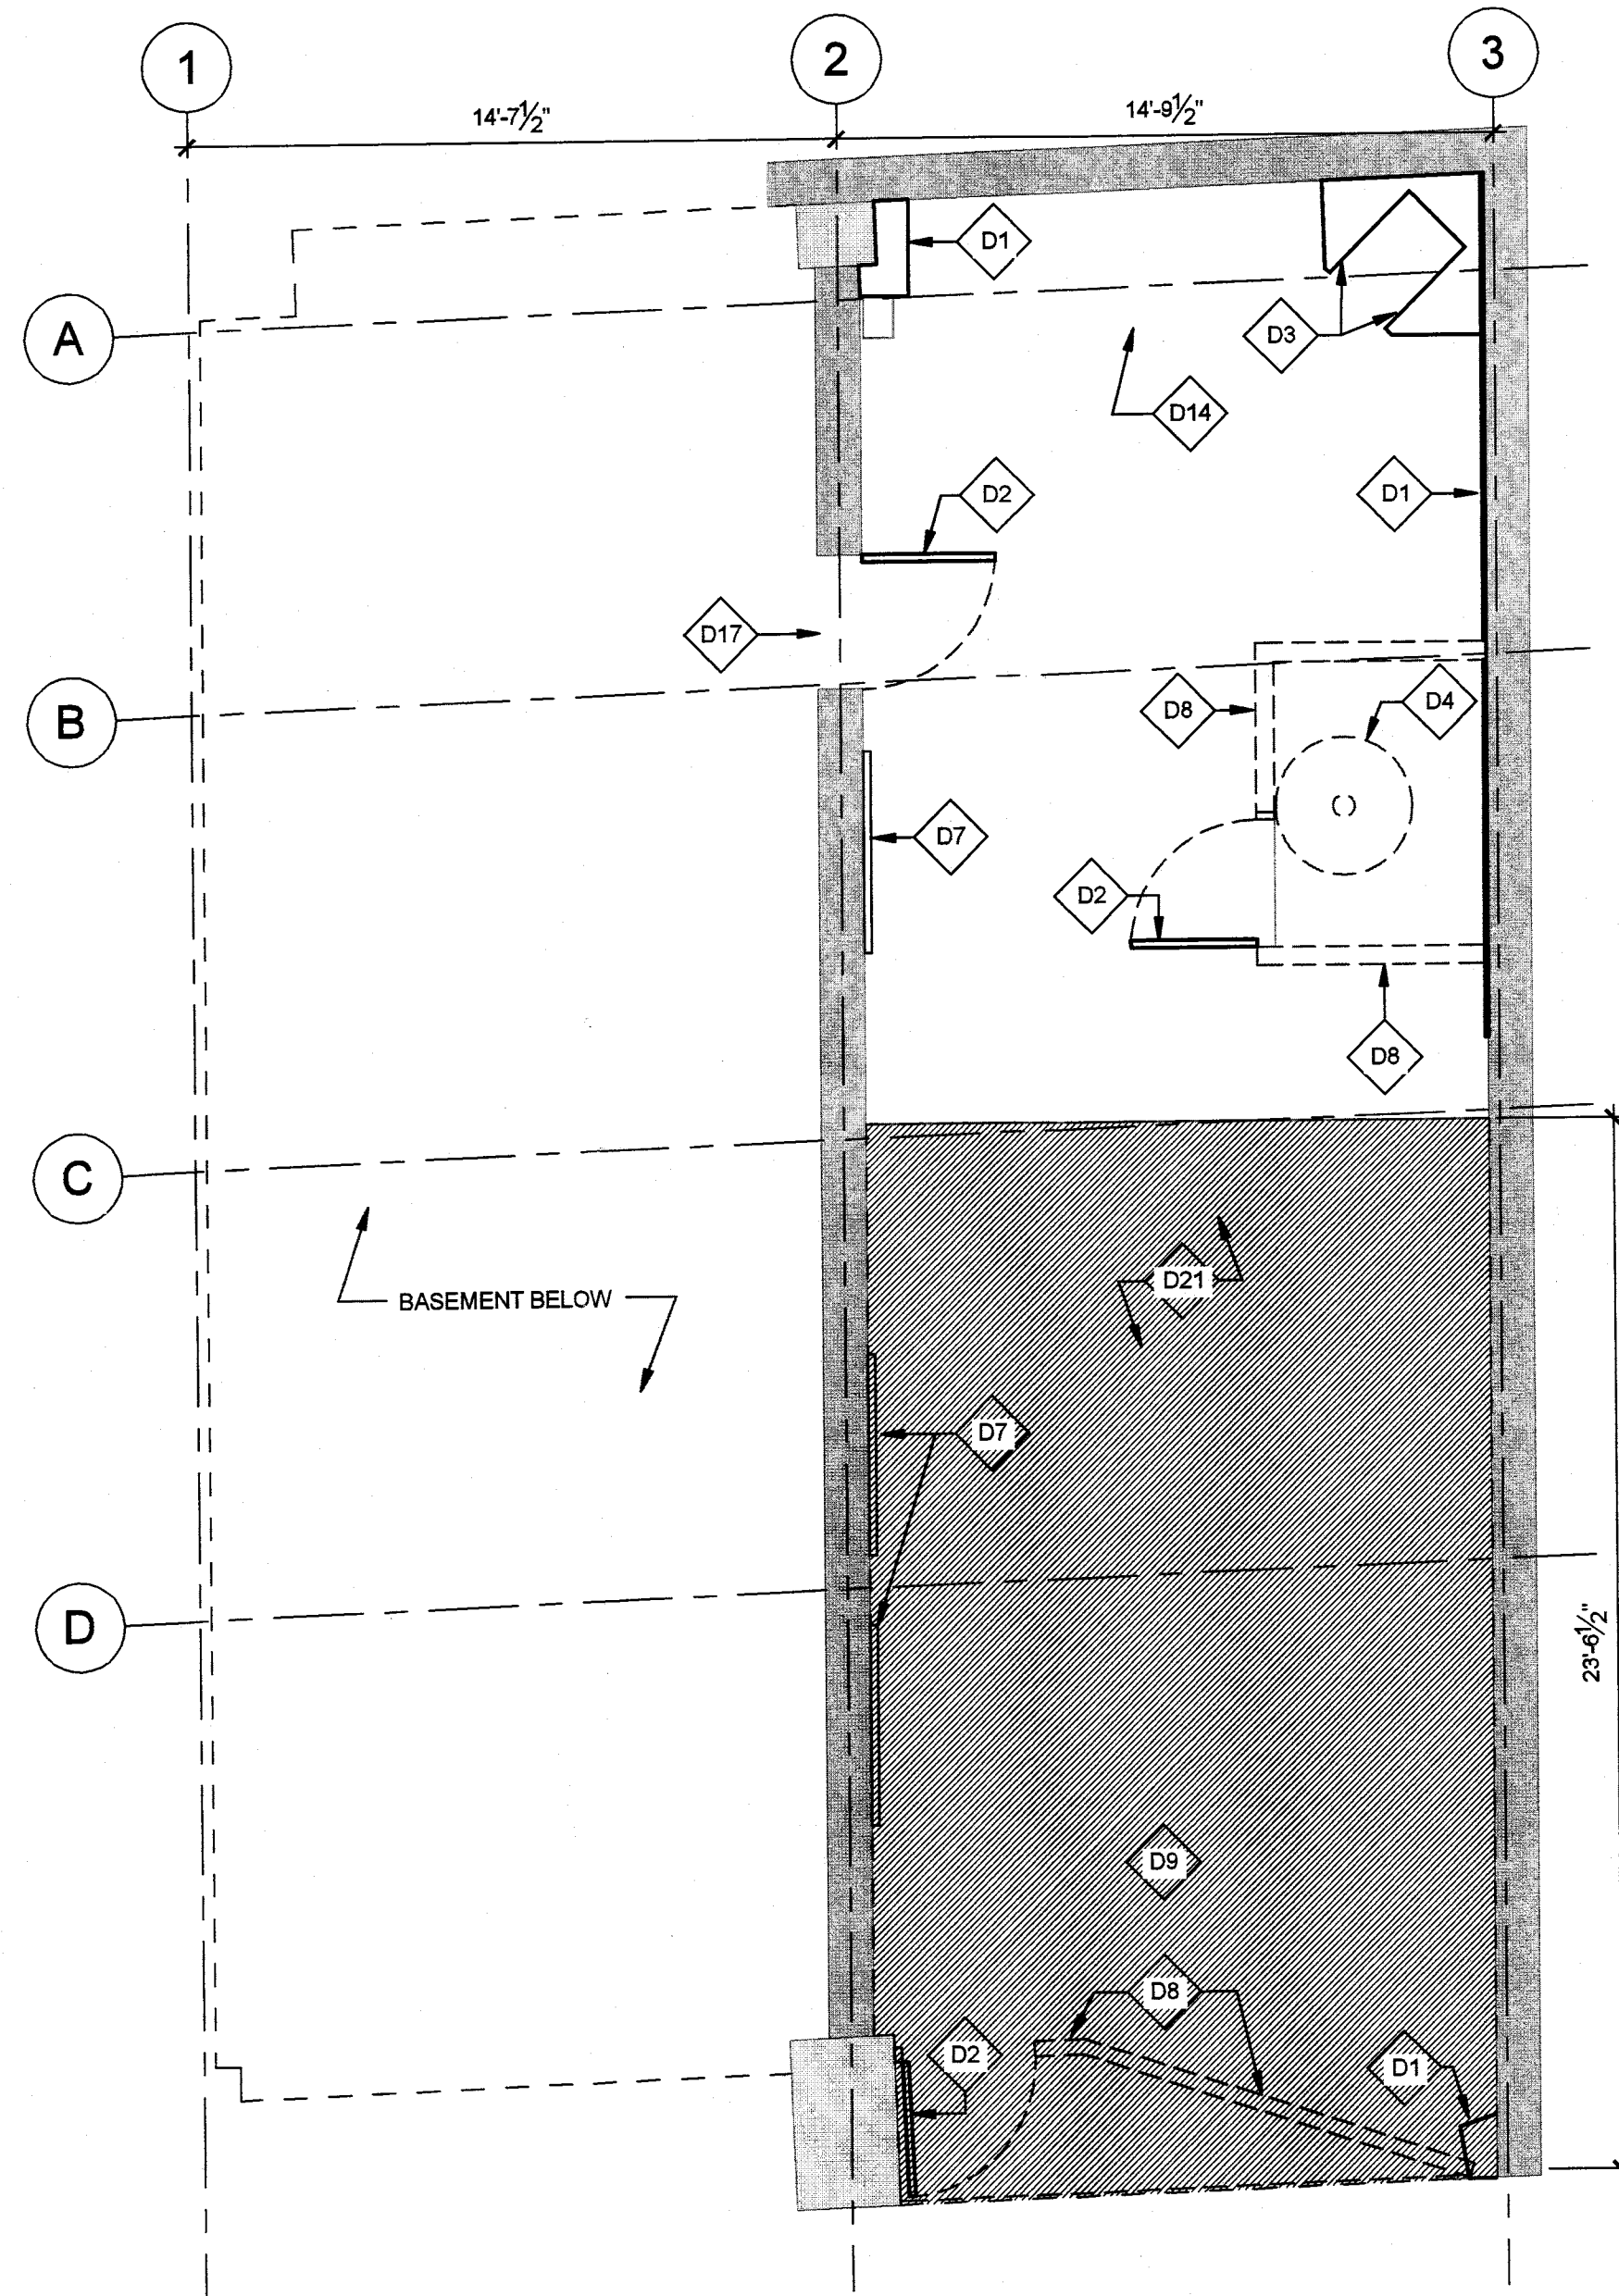

② FIRST FLOOR DEMOLITION PLAN
1/4" = 1'-0"

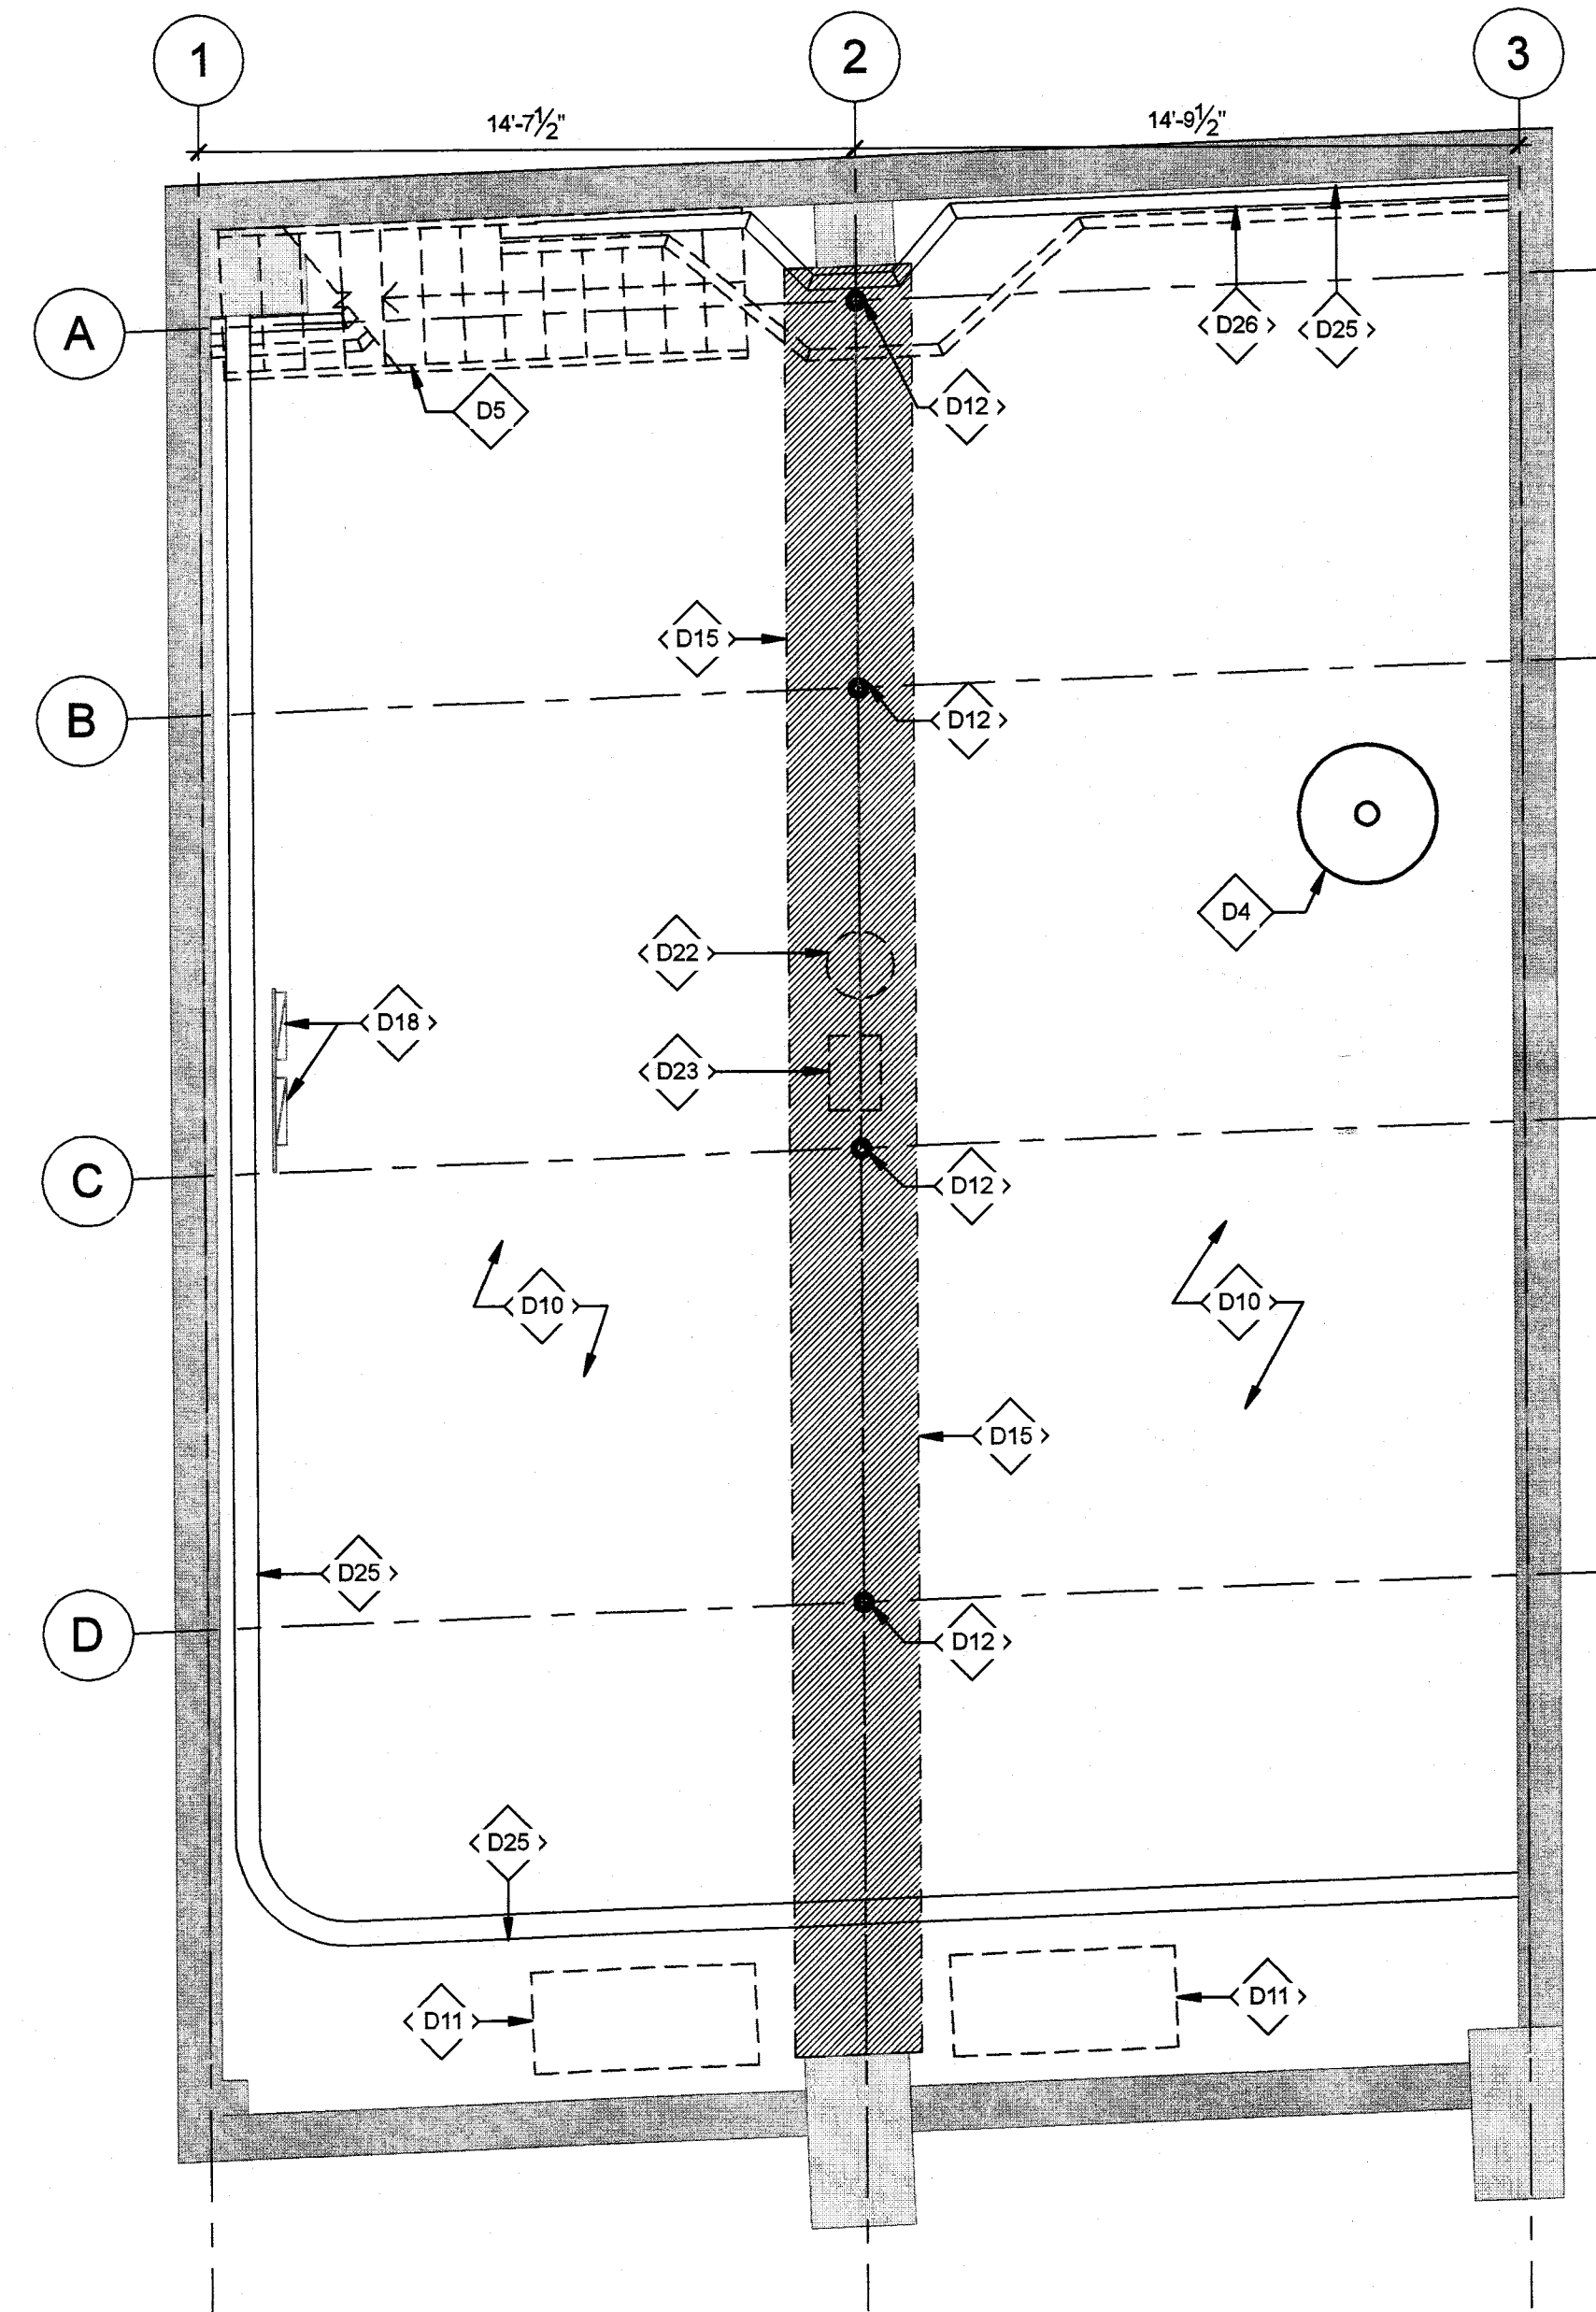

① LOWER LEVEL DEMOLITION PLAN
1/4" = 1'-0"

(AJC)2

Architecture

(t) 617.233.2791
info@casabrestaurant.com
12 Belmont Street
Somerville, Ma 02143

These drawings are the exclusive property of the Architect and its consultants and shall be used by authorized personnel only. The use, exhibition and /or reproduction of these documents without written permission is prohibited. ©

Consultants


Structural Engineer
LA Fues Partners
101 Federal st 502 Boston, Ma 02110

M/E/P Engineer
CSI Engineers LLC
999 Broadway 206 Saugus, Ma 01906

Kitchen Consultant
A.T. McDonald & Assoc.
735 Main Street Shrewsbury, Ma 01545

PROJECT: **Casa B**

253 Washington St
Somerville, Ma

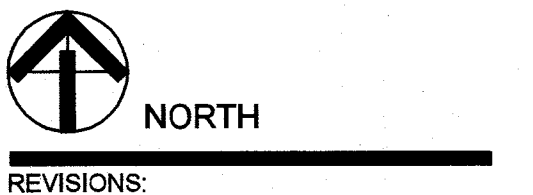



REVISIONS:

PROJECT NO: 10001.00
SCALE: 1/4" = 1'-0"
DRAWN BY: ajc CHECKED BY: ajc
ISSUE: PERMIT SET
DATE: 04.18.11
SHEET NAME:

DEMOLITION PLANS

SHEET NO: **A0.02**


RECEIVED
S.P.C.D. AND
PLANNING DEPT.
2011 MAY 23 AM 10:56

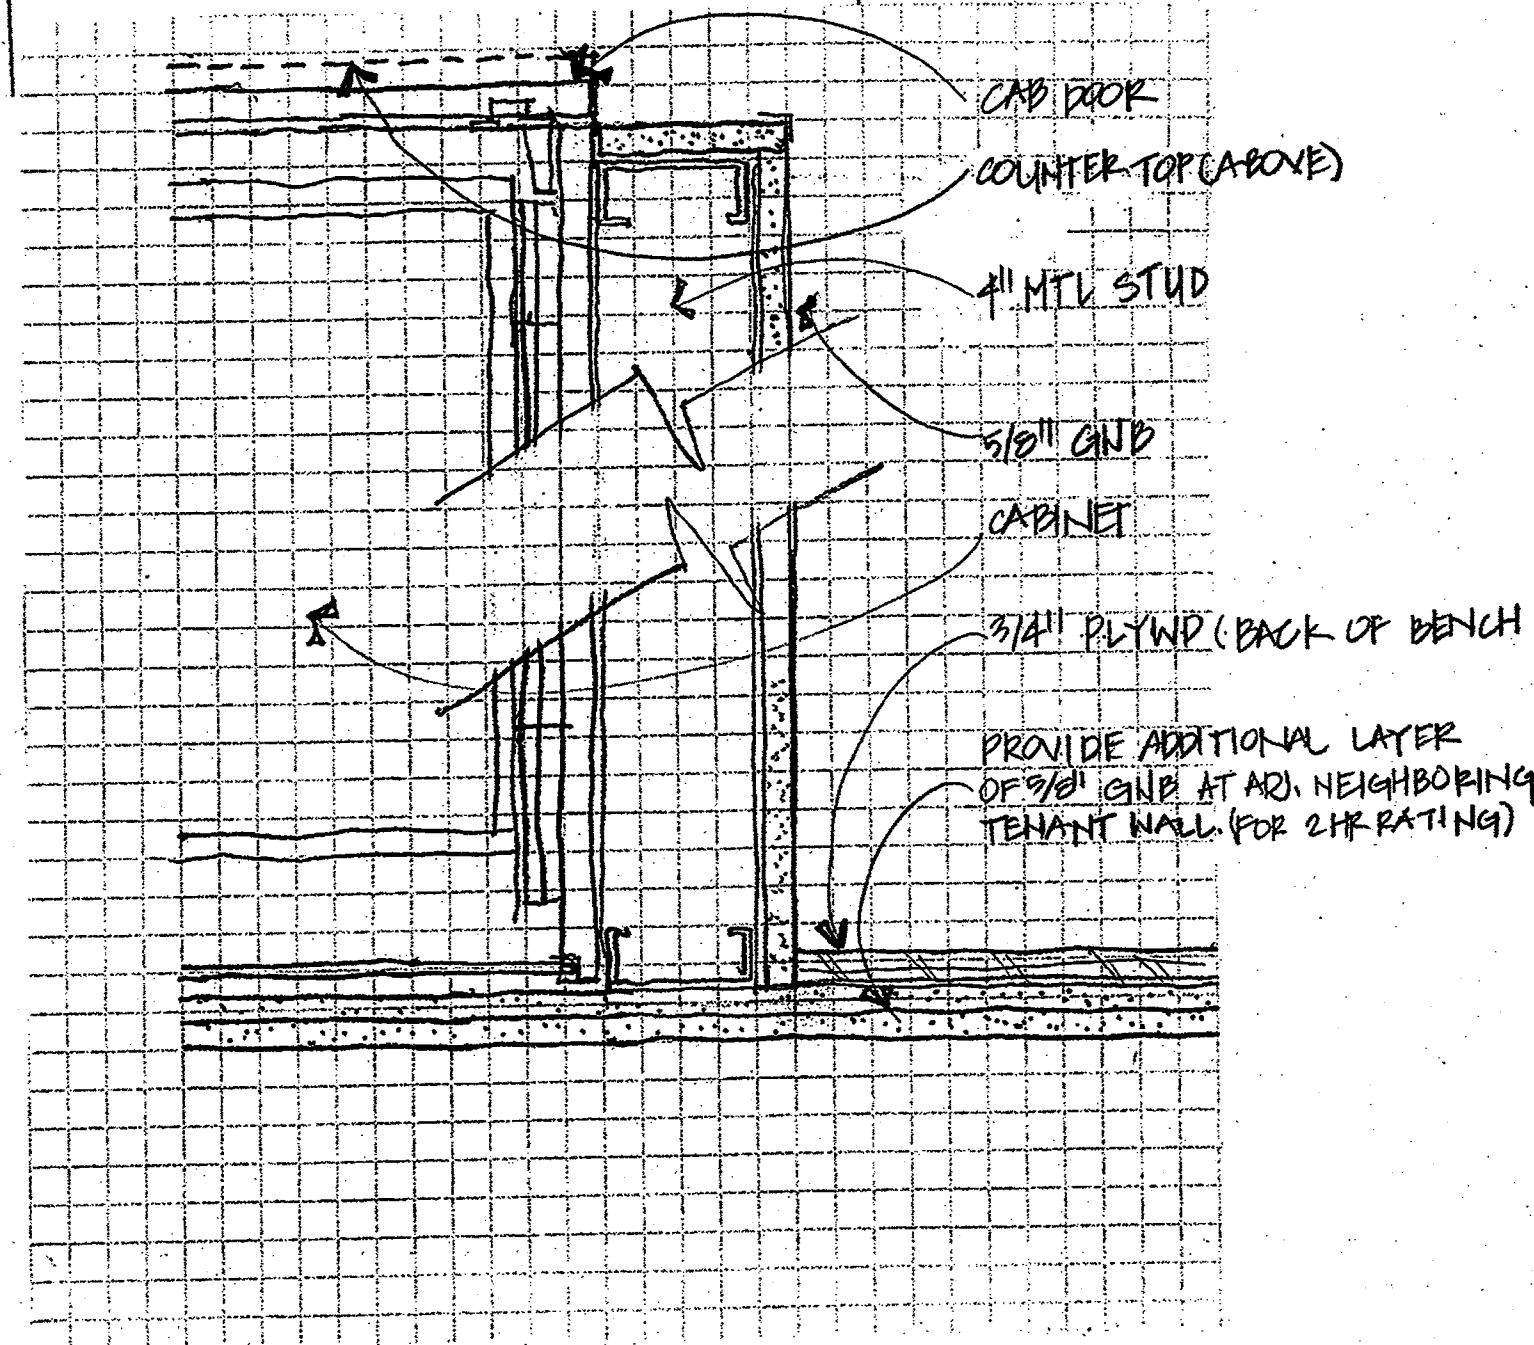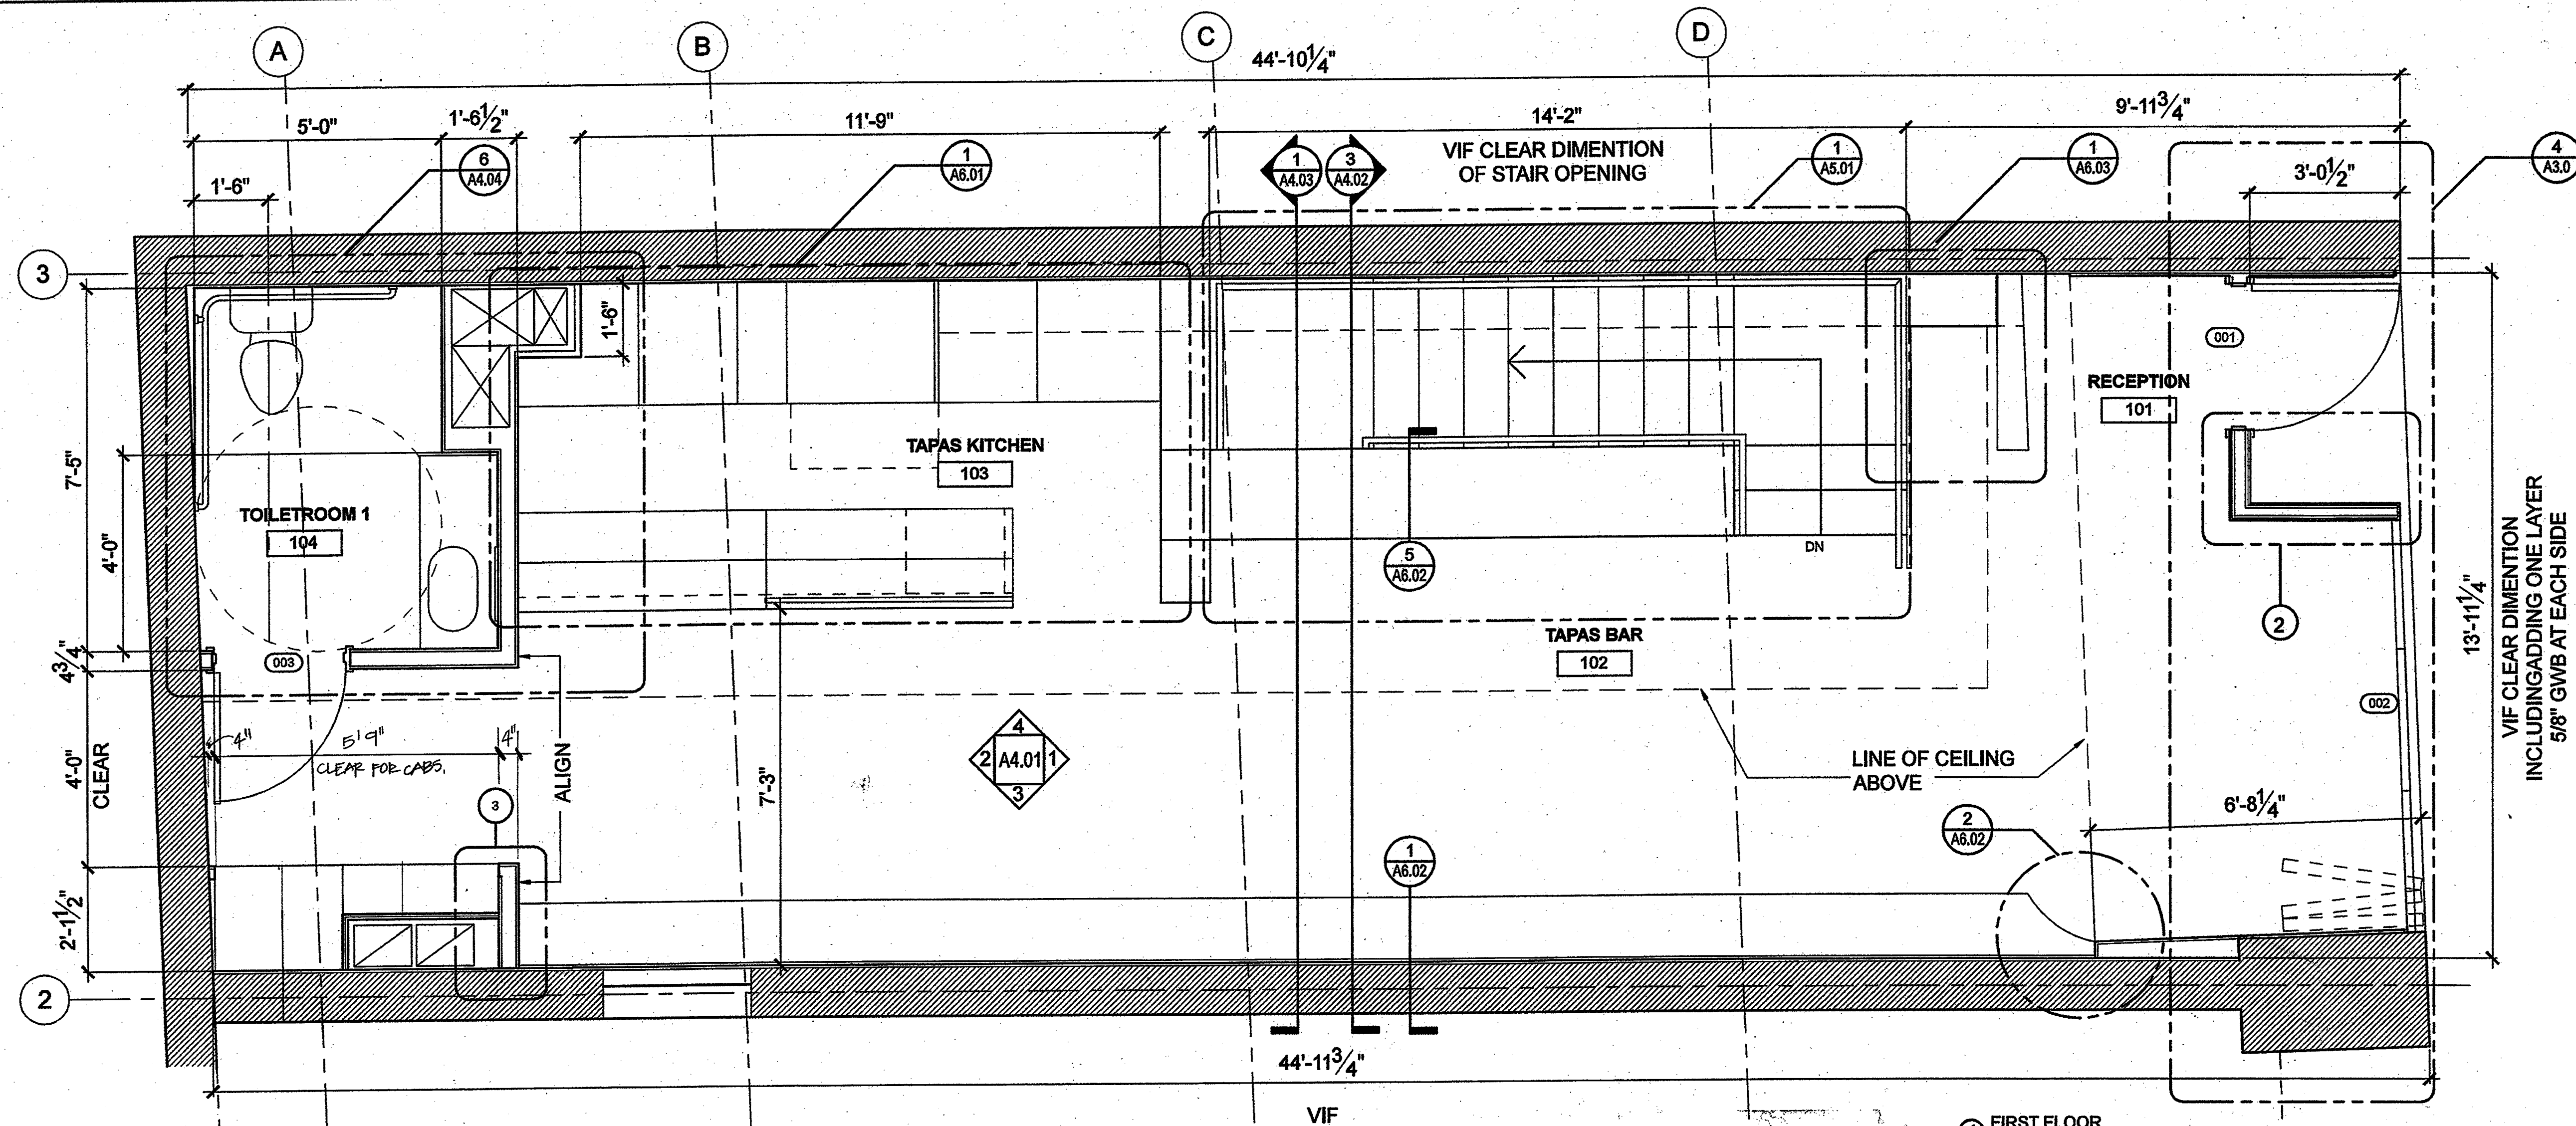

3. GNB CABINET INSTALLATION
3" = 1'-0"

GENERAL NOTES

1. ALL NEW WALL TO BE 4" MTL STUDS WITH 5/8" LAYER OF GNB AND SKIM COAT PLASTER.
2. PROVIDE CONTINUOUS 2 HOUR SEPERATION AT ALL ADJ. NEIGHBORING TENANTS.
3. PROVIDE AT ALL CONDITIONS 2" AFF. OF CEMENT BOARD, LOWER LEVEL ONLY.

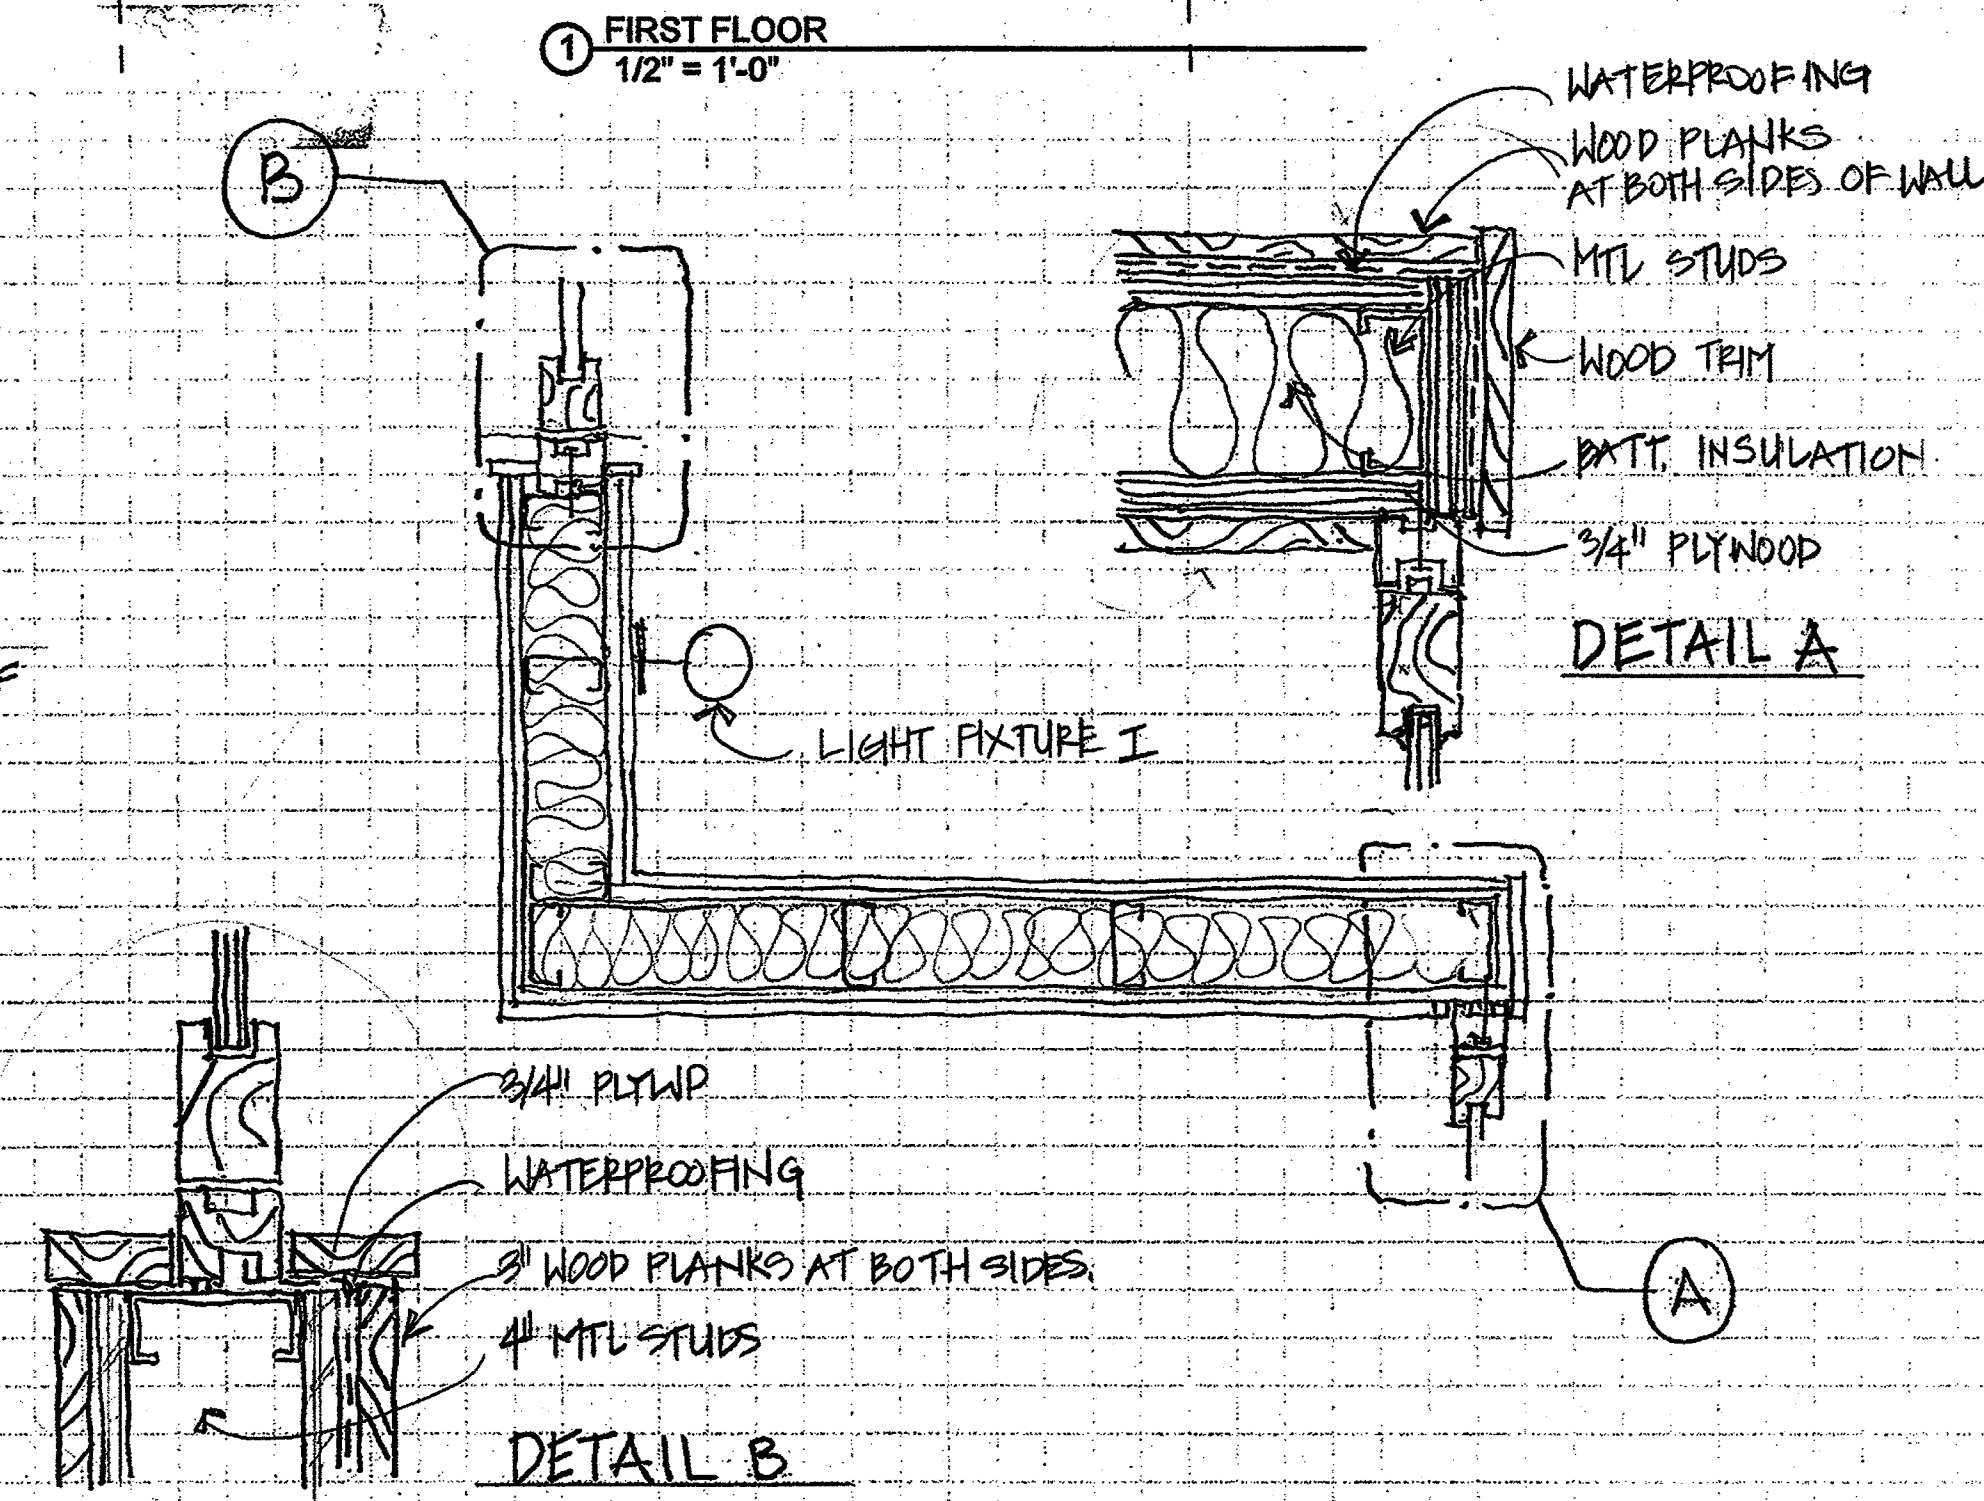

(AJC)2 Architecture

(t) 617.233.2791
info@casabrestaurant.com
12 Belmont Street
Somerville, Ma 02143

These drawings are the exclusive property of the Architect and its consultants and shall be used by authorized personnel only. The use, exhibition and for reproduction of these documents without written permission is prohibited. ®

Consultants

Structural Engineer
LA Fines Partners
101 Federal st 502 Boston, Ma 02110

M/E/P Engineer
CSI Engineers LLC
999 Broadway 208 Saugus, Ma 01906

Kitchen Consultant
A.T. McDonald & Assoc.
735 Main Street Shrewsbury, Ma 01545

PROJECT:

Casa B

253 Washington St
Somerville, Ma



NORTH

REVISIONS:

NO.	DESCRIPTION

PROJECT NO: 10001.00
SCALE: 1/2" = 1'-0"
DRAWN BY: ajc CHECKED BY: ajc
ISSUE: PERMIT SET
DATE: 04.18.11


SHEET NAME:

**FIRST FLOOR
PLAN**

SHEET NO:

A1.01

RECEIVED
S.C.D. AND
PLANNING DEPT.
2011 MAY 23 AM 10:57

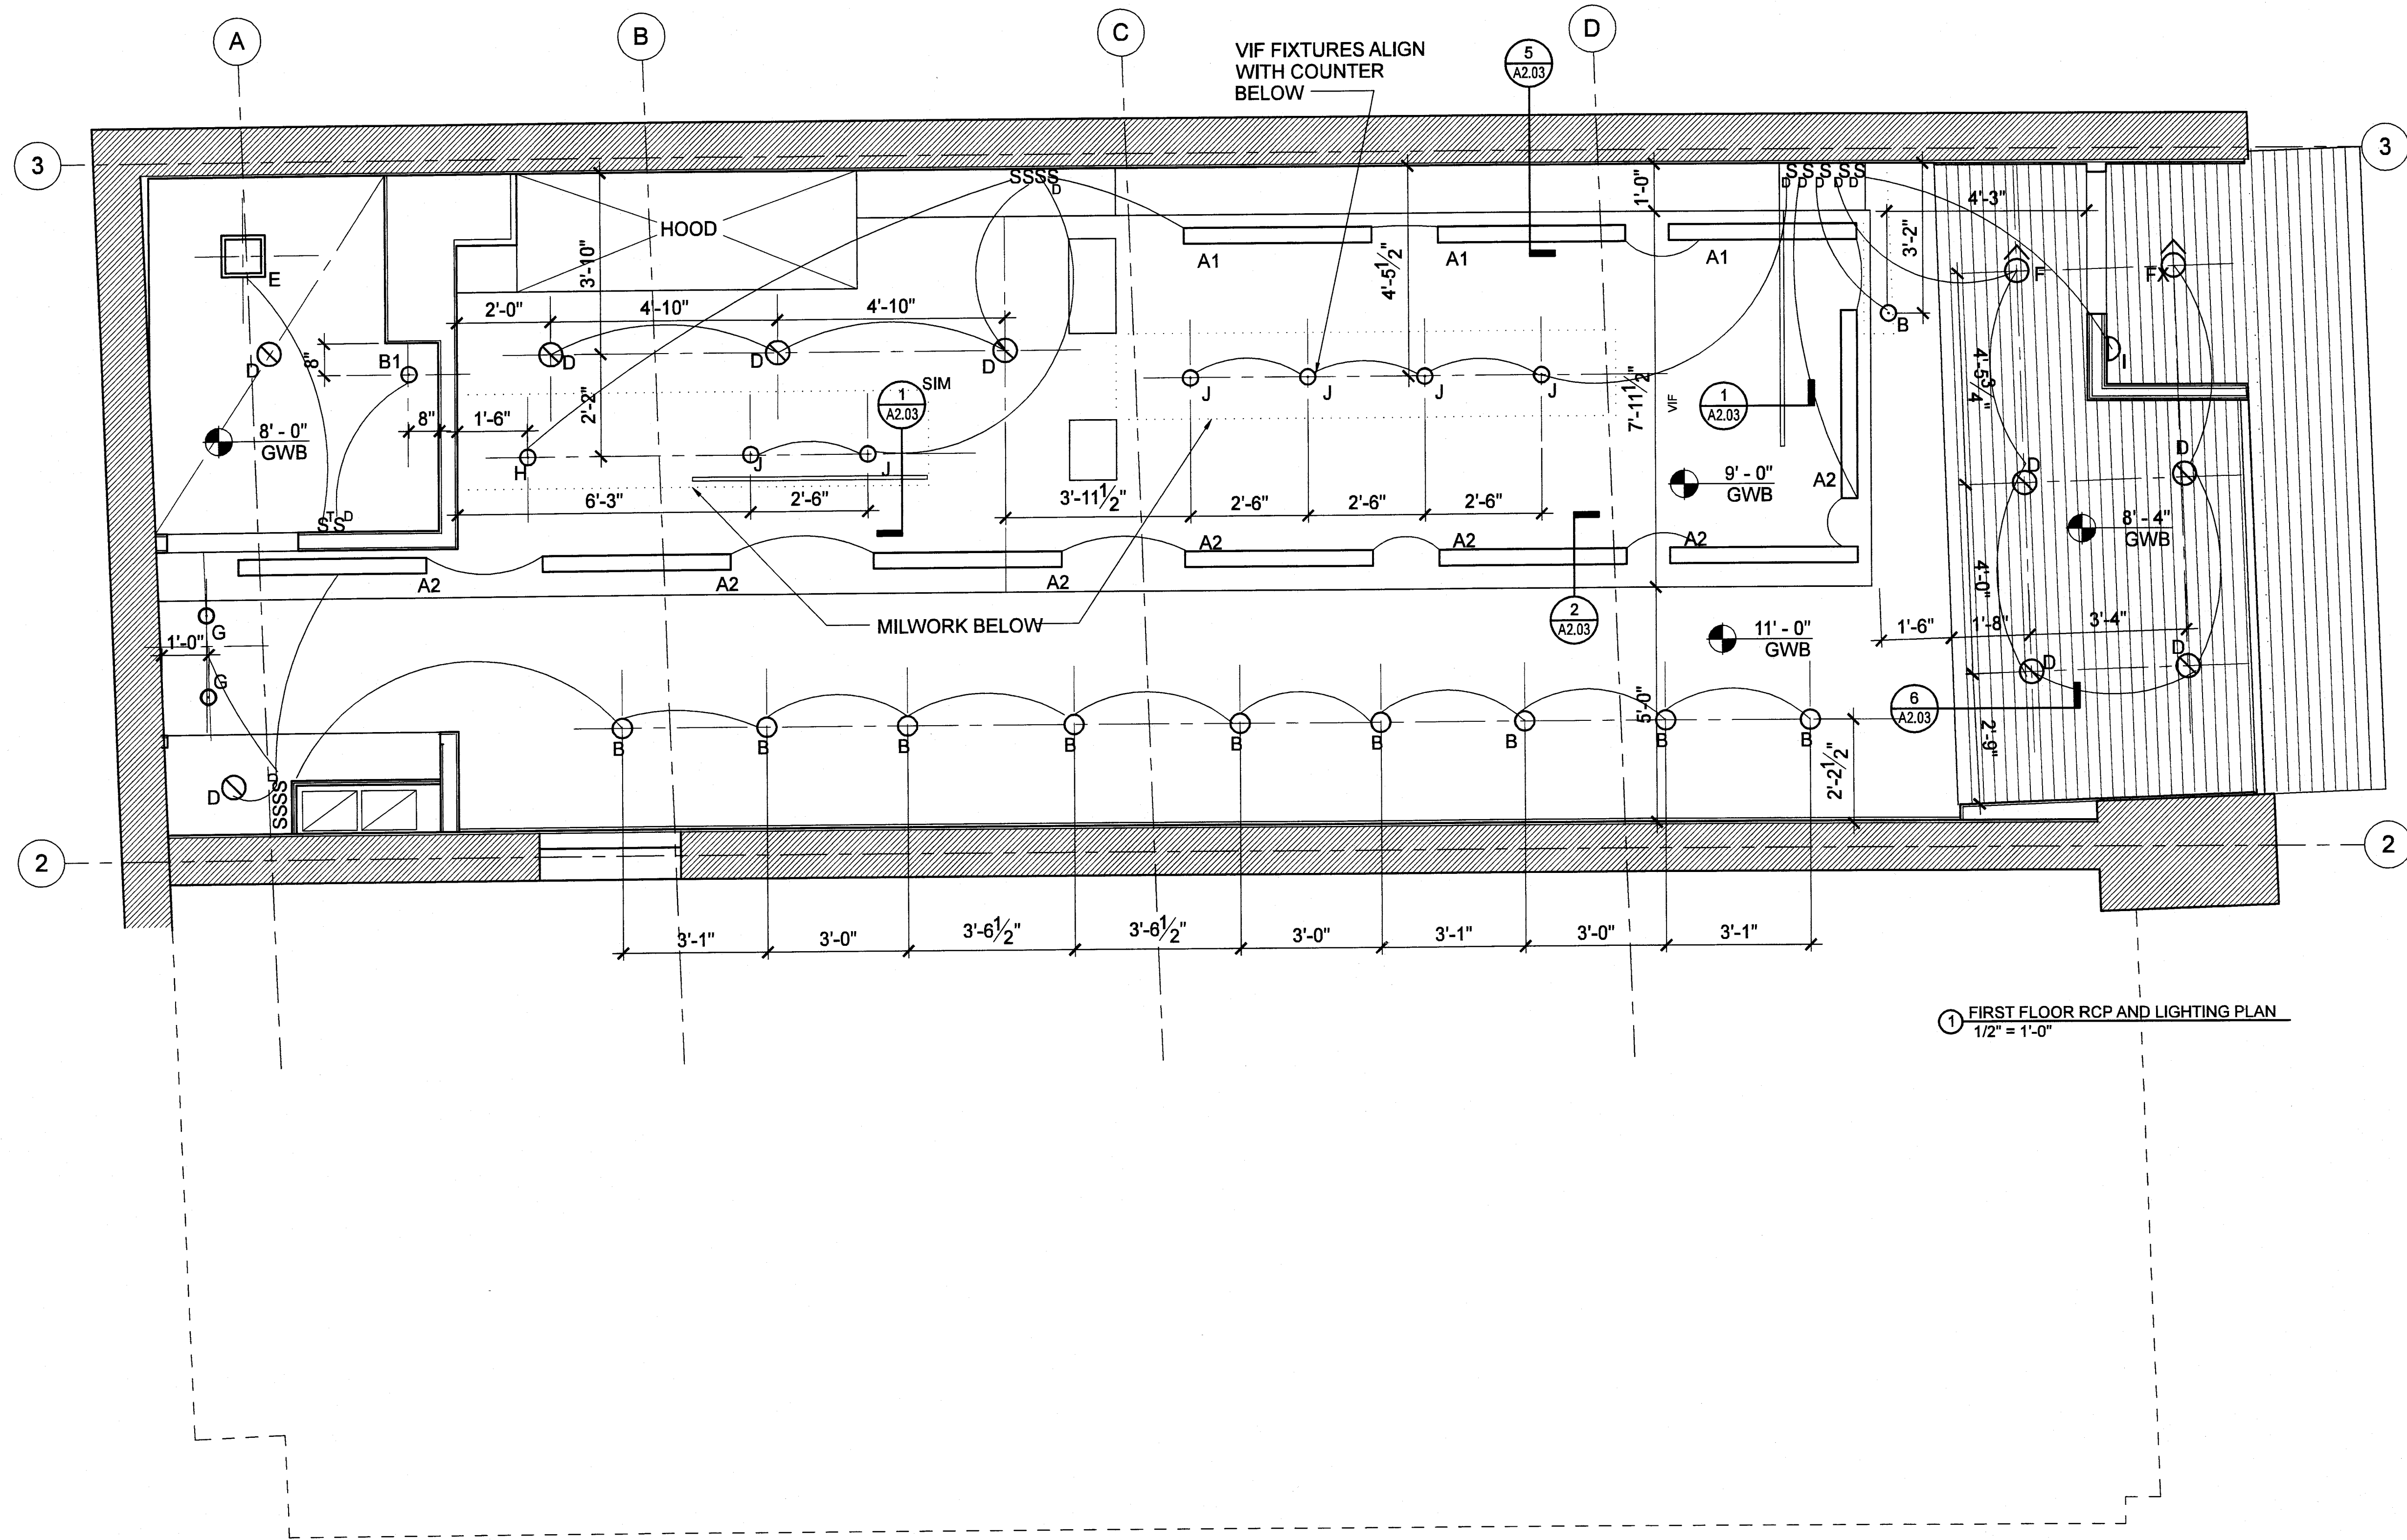

1 FIRST FLOOR RCP AND LIGHTING PLAN
1/2" = 1'-0"

(AJC)2

Architecture

(t) 617.233.2791
info@casabrestaurant.com
12 Belmont Street
Somerville, Ma 02143

These drawings are the exclusive property of the Architect and its consultants and shall be used by authorized personnel only. The use, exhibition and/or reproduction of these documents without written permission is prohibited. (R)

Consultants

Structural Engineer
LA Fues Partners
101 Federal st 502 Boston, Ma 02110

M/E/P Engineer
CSI Engineers LLC
999 Broadway 206 Saugus, Ma 01906

Kitchen Consultant
A.T. McDonald & Assoc.
735 Main Street Shrewsbury, Ma 01545

PROJECT: Casa B

253 Washington St
Somerville, Ma




REVISIONS:	

PROJECT NO:	10001.00
SCALE:	1/2" = 1'-0"
DRAWN BY:	ajc
CHECKED BY:	ajc
ISSUE:	PERMIT SET
DATE:	04.11.11
SHEET NAME:	

FIRST FLOOR REFLECTED CEILING PLAN

SHEET NO:
A2.01

RECEIVED
S.P.D. AND
PLANNING DEPT.
2011 MAY 23 AM 10:57

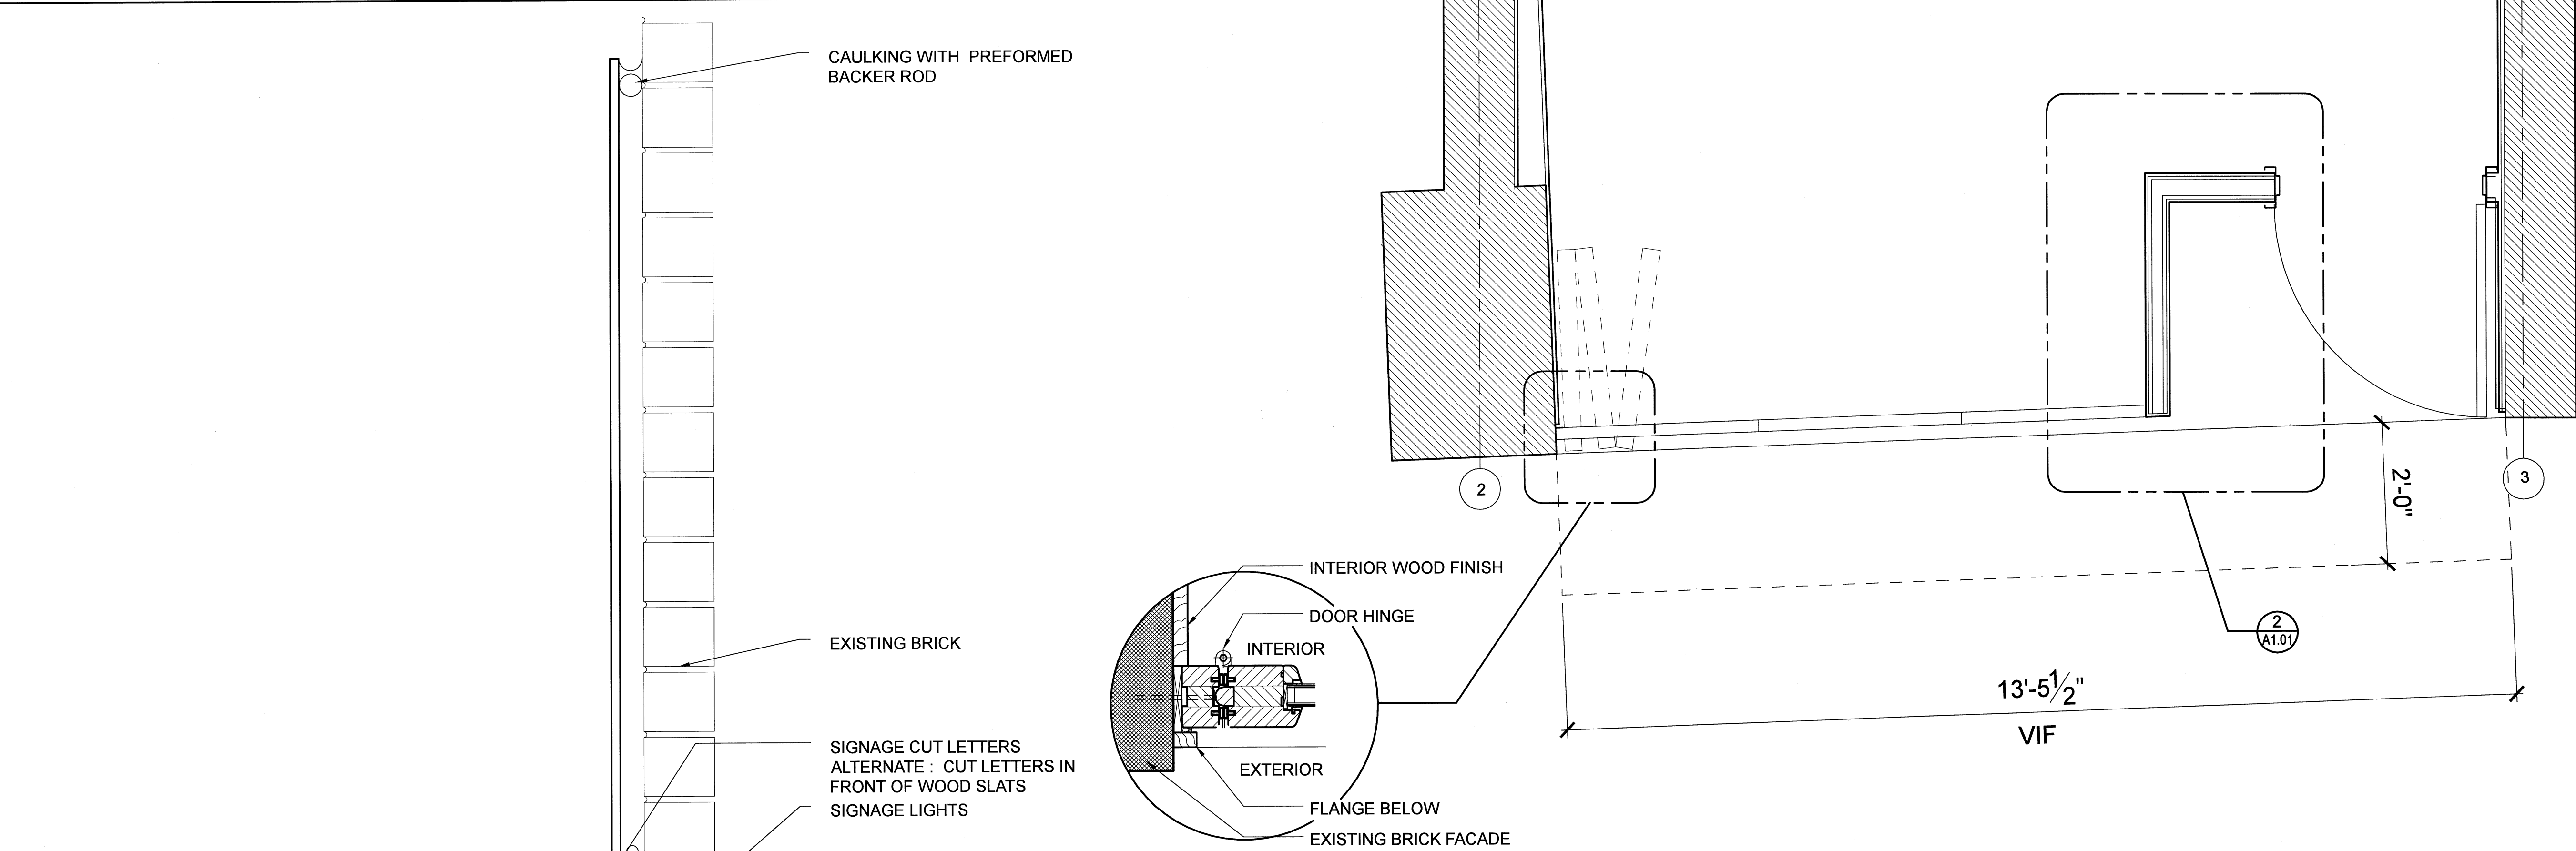

③ ENTRY ENLARGED PLAN
3" = 1'-0"

① Exterior elevation
1/2" = 1'-0"

(AJC)2

Architecture

(t) 617.233.2791
info@casabrestaurant.com
12 Belmont Street
Somerville, Ma 02143

These drawings are the exclusive property of the Architect and its consultants and shall be used by authorized personnel only. The use, exhibition and/or reproduction of these documents without written permission is prohibited. ®

RECEIVED
S.P.C.D. AND
PLANNING DEPT.
2011 JUN -2 AM 8:19

PROJECT:

Casa B

253 Washington St
Somerville, Ma



REVISIONS:
ALTERNATE INFORMATION ADDED 5/31/11

PROJECT NO: 10001.00

SCALE: 1/2" = 1'-0"

DRAWN BY: CHECKED BY:

ISSUE:

DATE:

SHEET NAME:


**EXTERIOR
ELEVATION AND
DETAILS**

SHEET NO:

A3.0

RECEIVED
S.P.C.D. AND
PLANNING DEPT.

2011 MAY 23 AM 10: 54

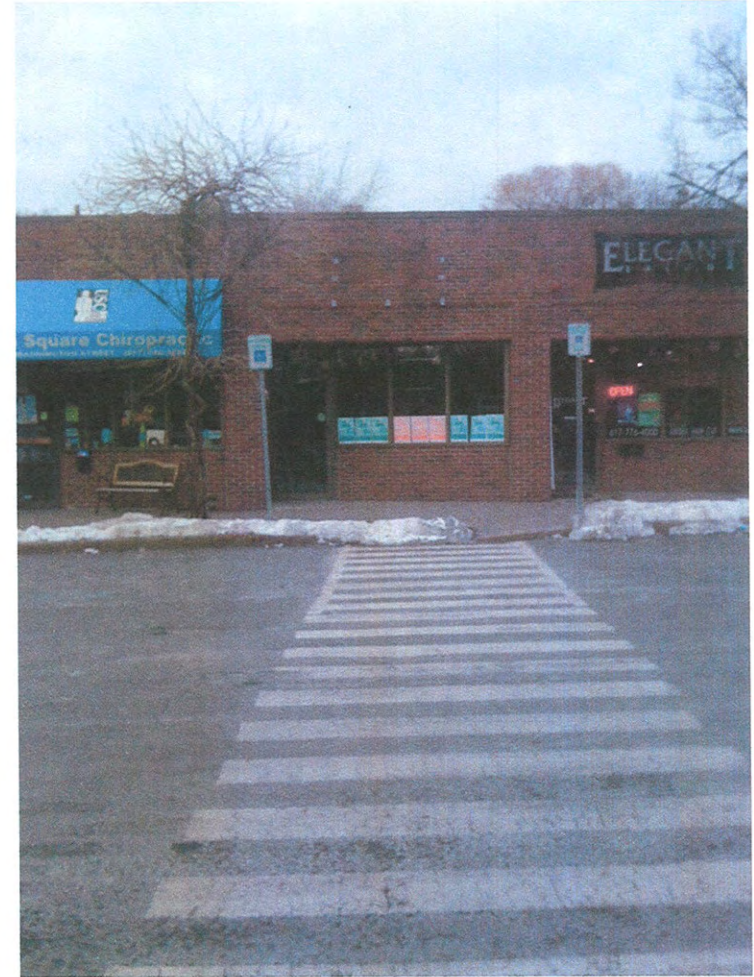

RECEIVED
S.P.C.D. AND
PLANNING DEPT.

2011 MAY 23 AM 10:54

